


P-03

Plumbing Plan - option A

1:40

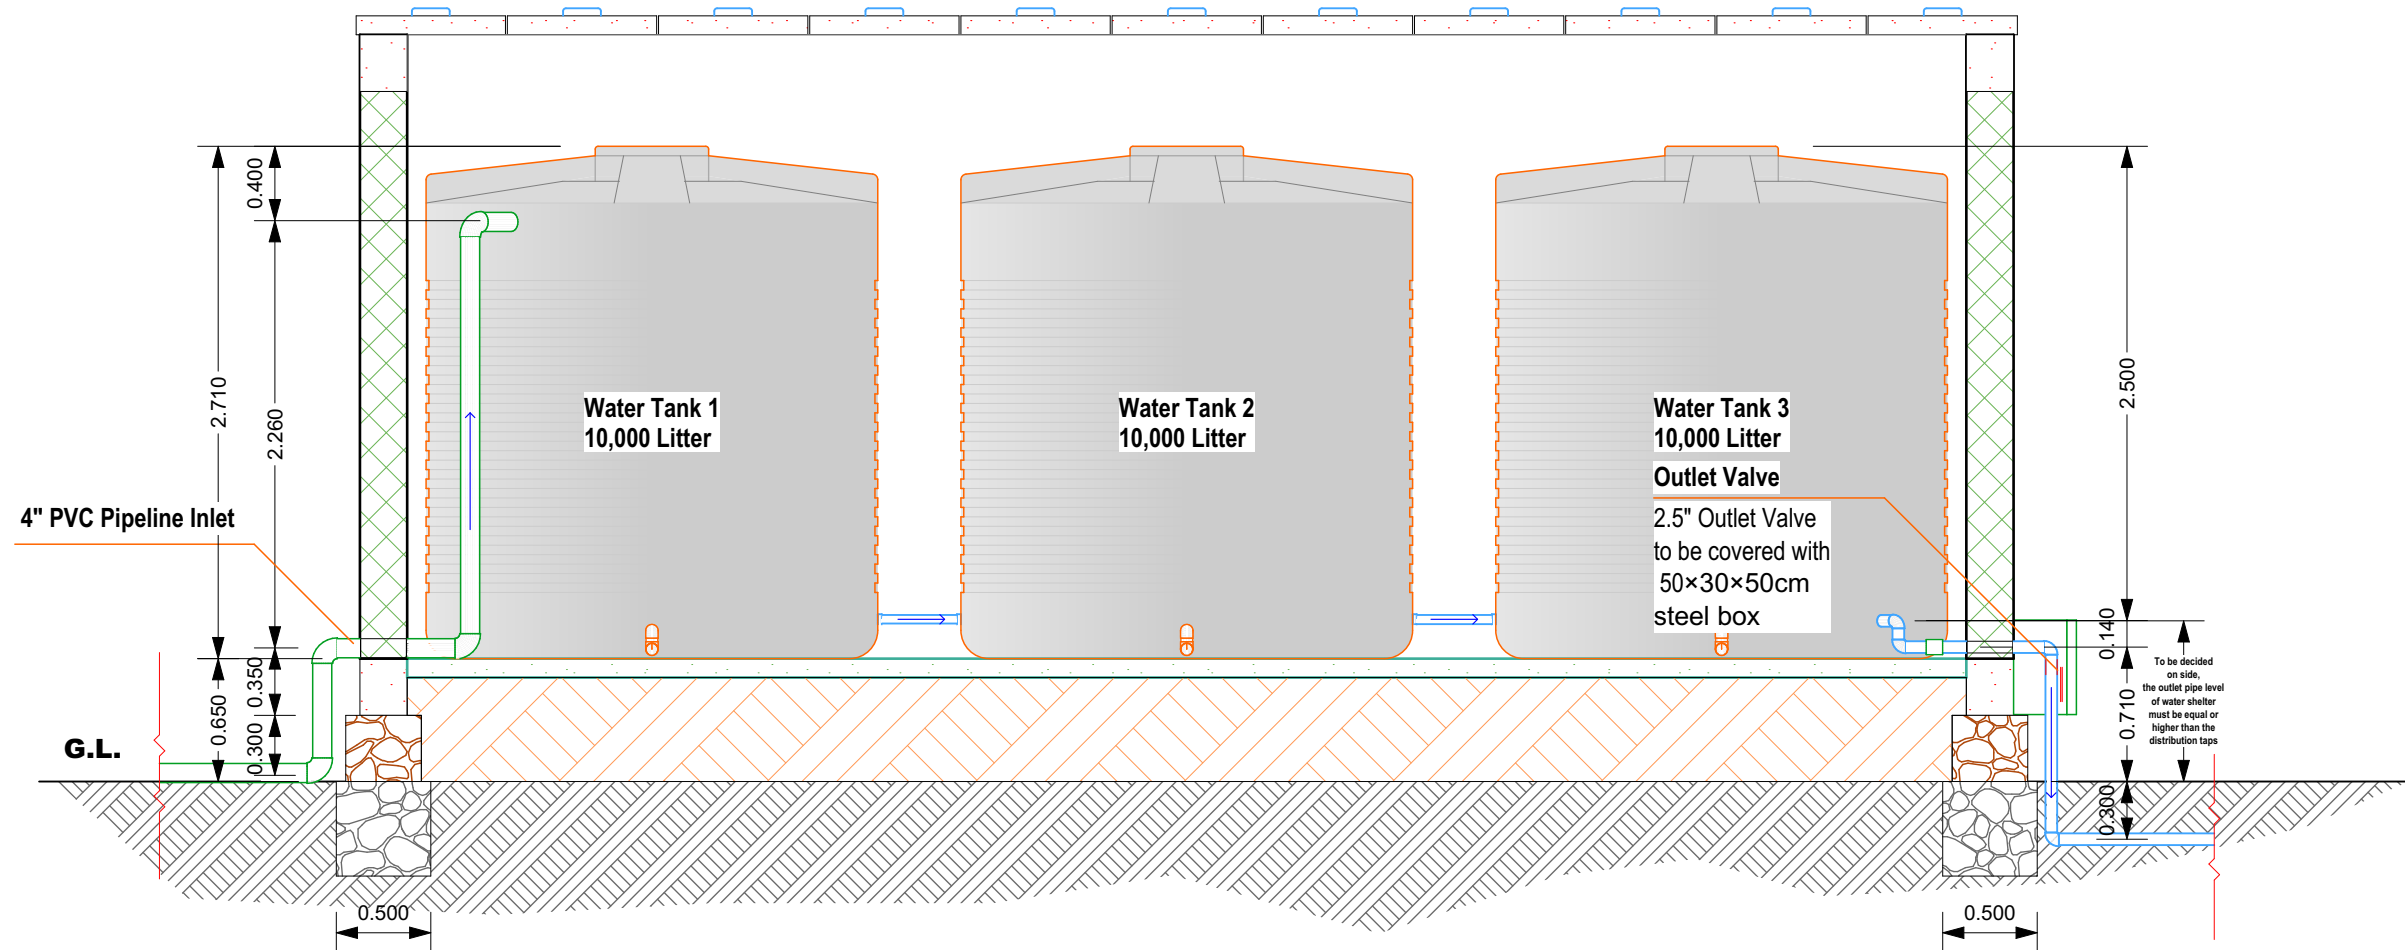

S-03

Secion S 3-3

1:40

KEY LEGEND		
NO.	SYMBOL	NAME
1		4" PPR Pipeline (inlet pipe)
2		2.5" PPR Pipeline (intermediate pipe)
3		2.5" PPR Pipeline (water destruction pipe)
4		2.5" PPR Pipeline (outlet pipe)
5		4" PVC Pipeline (water wastage pipe)
6		One way valve
7		Over flow controller
8		2.5" Valve
9		Copper water tap
10		Water direction

Company Title		
JOPHCO For Construction and Engineering co. Ltd.		
Tompsoning Juba Central Equatoria +211		
Job Title		
Water Storage and Distribution Unit		
Boma Great Pibor South Sudan 211		
Drawing Name		
Plumbing Plan - option A, Secion S 3-3		
Owner:		
Terre Des Hommes		
Drawn by:		
Ahmed Mandel		
Date 1 Feb 2016		
Checked by:		
Bedr Aldeen Almagboul		
Date 1 Feb 2016		
Drawing Scale		
1:40, 1:87.31		
Layout ID		
A.01.2		
Status		
Revision		