

INT.405

20WEST 7th STREET
UPLAND, CA 91786

SHEET NAME

LIGHTING PLAN

SCALE

DRAWN BY


SULPISIO MEDRANO

DATE

6/24/09

SHEET#

INT 405

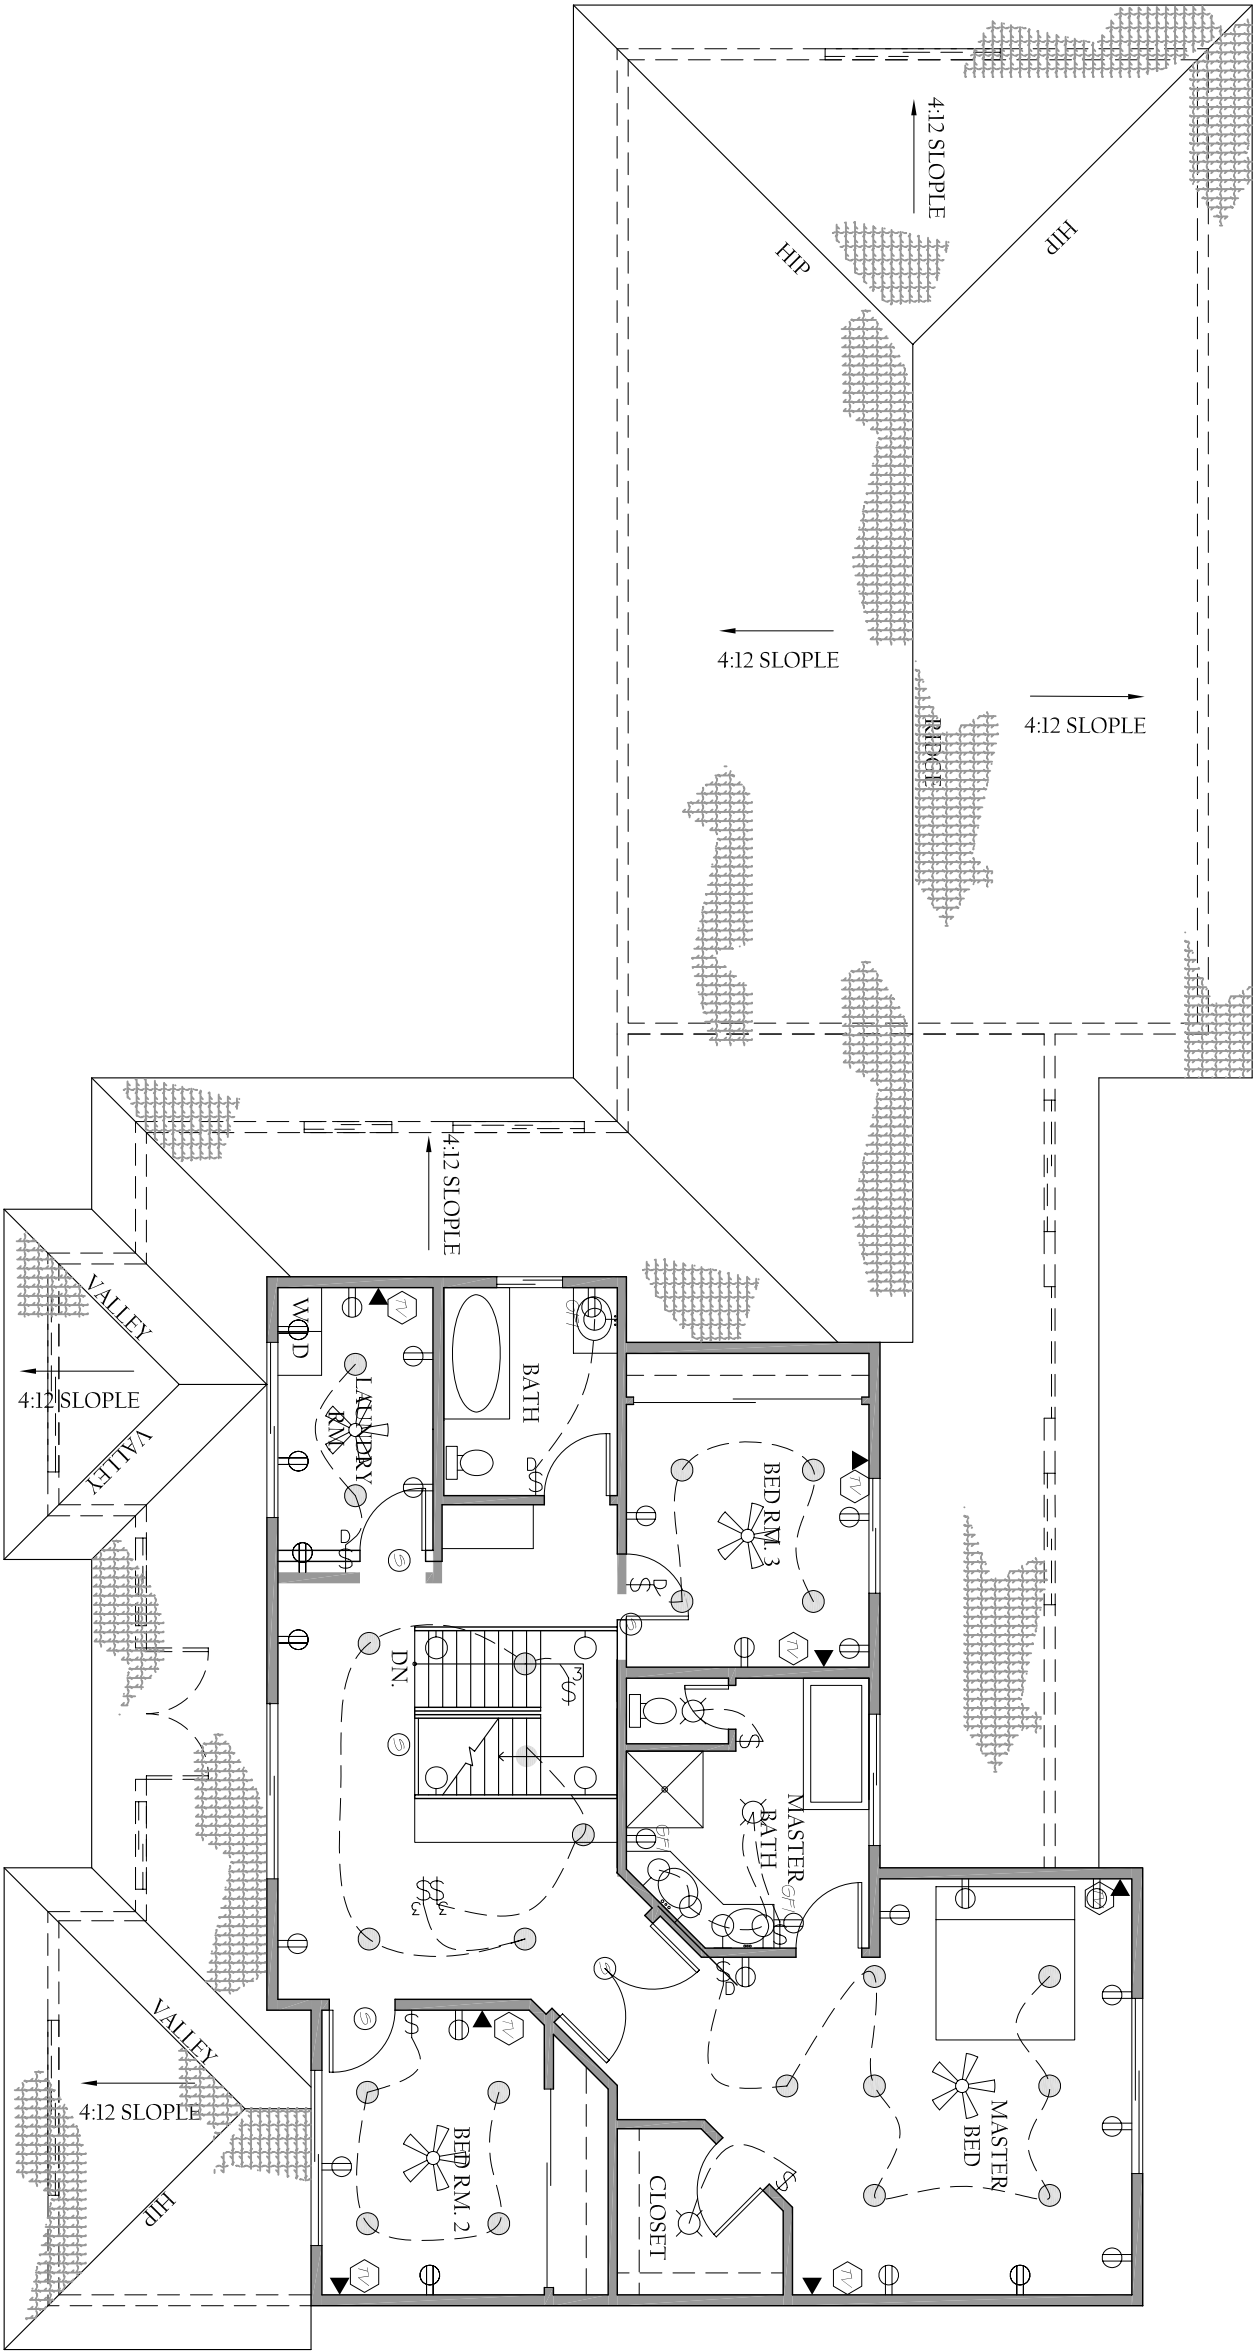

SCALE: 1/4"=1'-0"

