


ALL MATERIALS TO MATCH EXISTING UNLESS OTHERWISE NOTED


EXTENSION FLOOR LEVELS TO LINE THROUGH WITH THE FLOOR LEVELS IN THE EXISTING PROPERTY UNLESS OTHERWISE NOTED




Location plan - scale 1:1250 @ A1

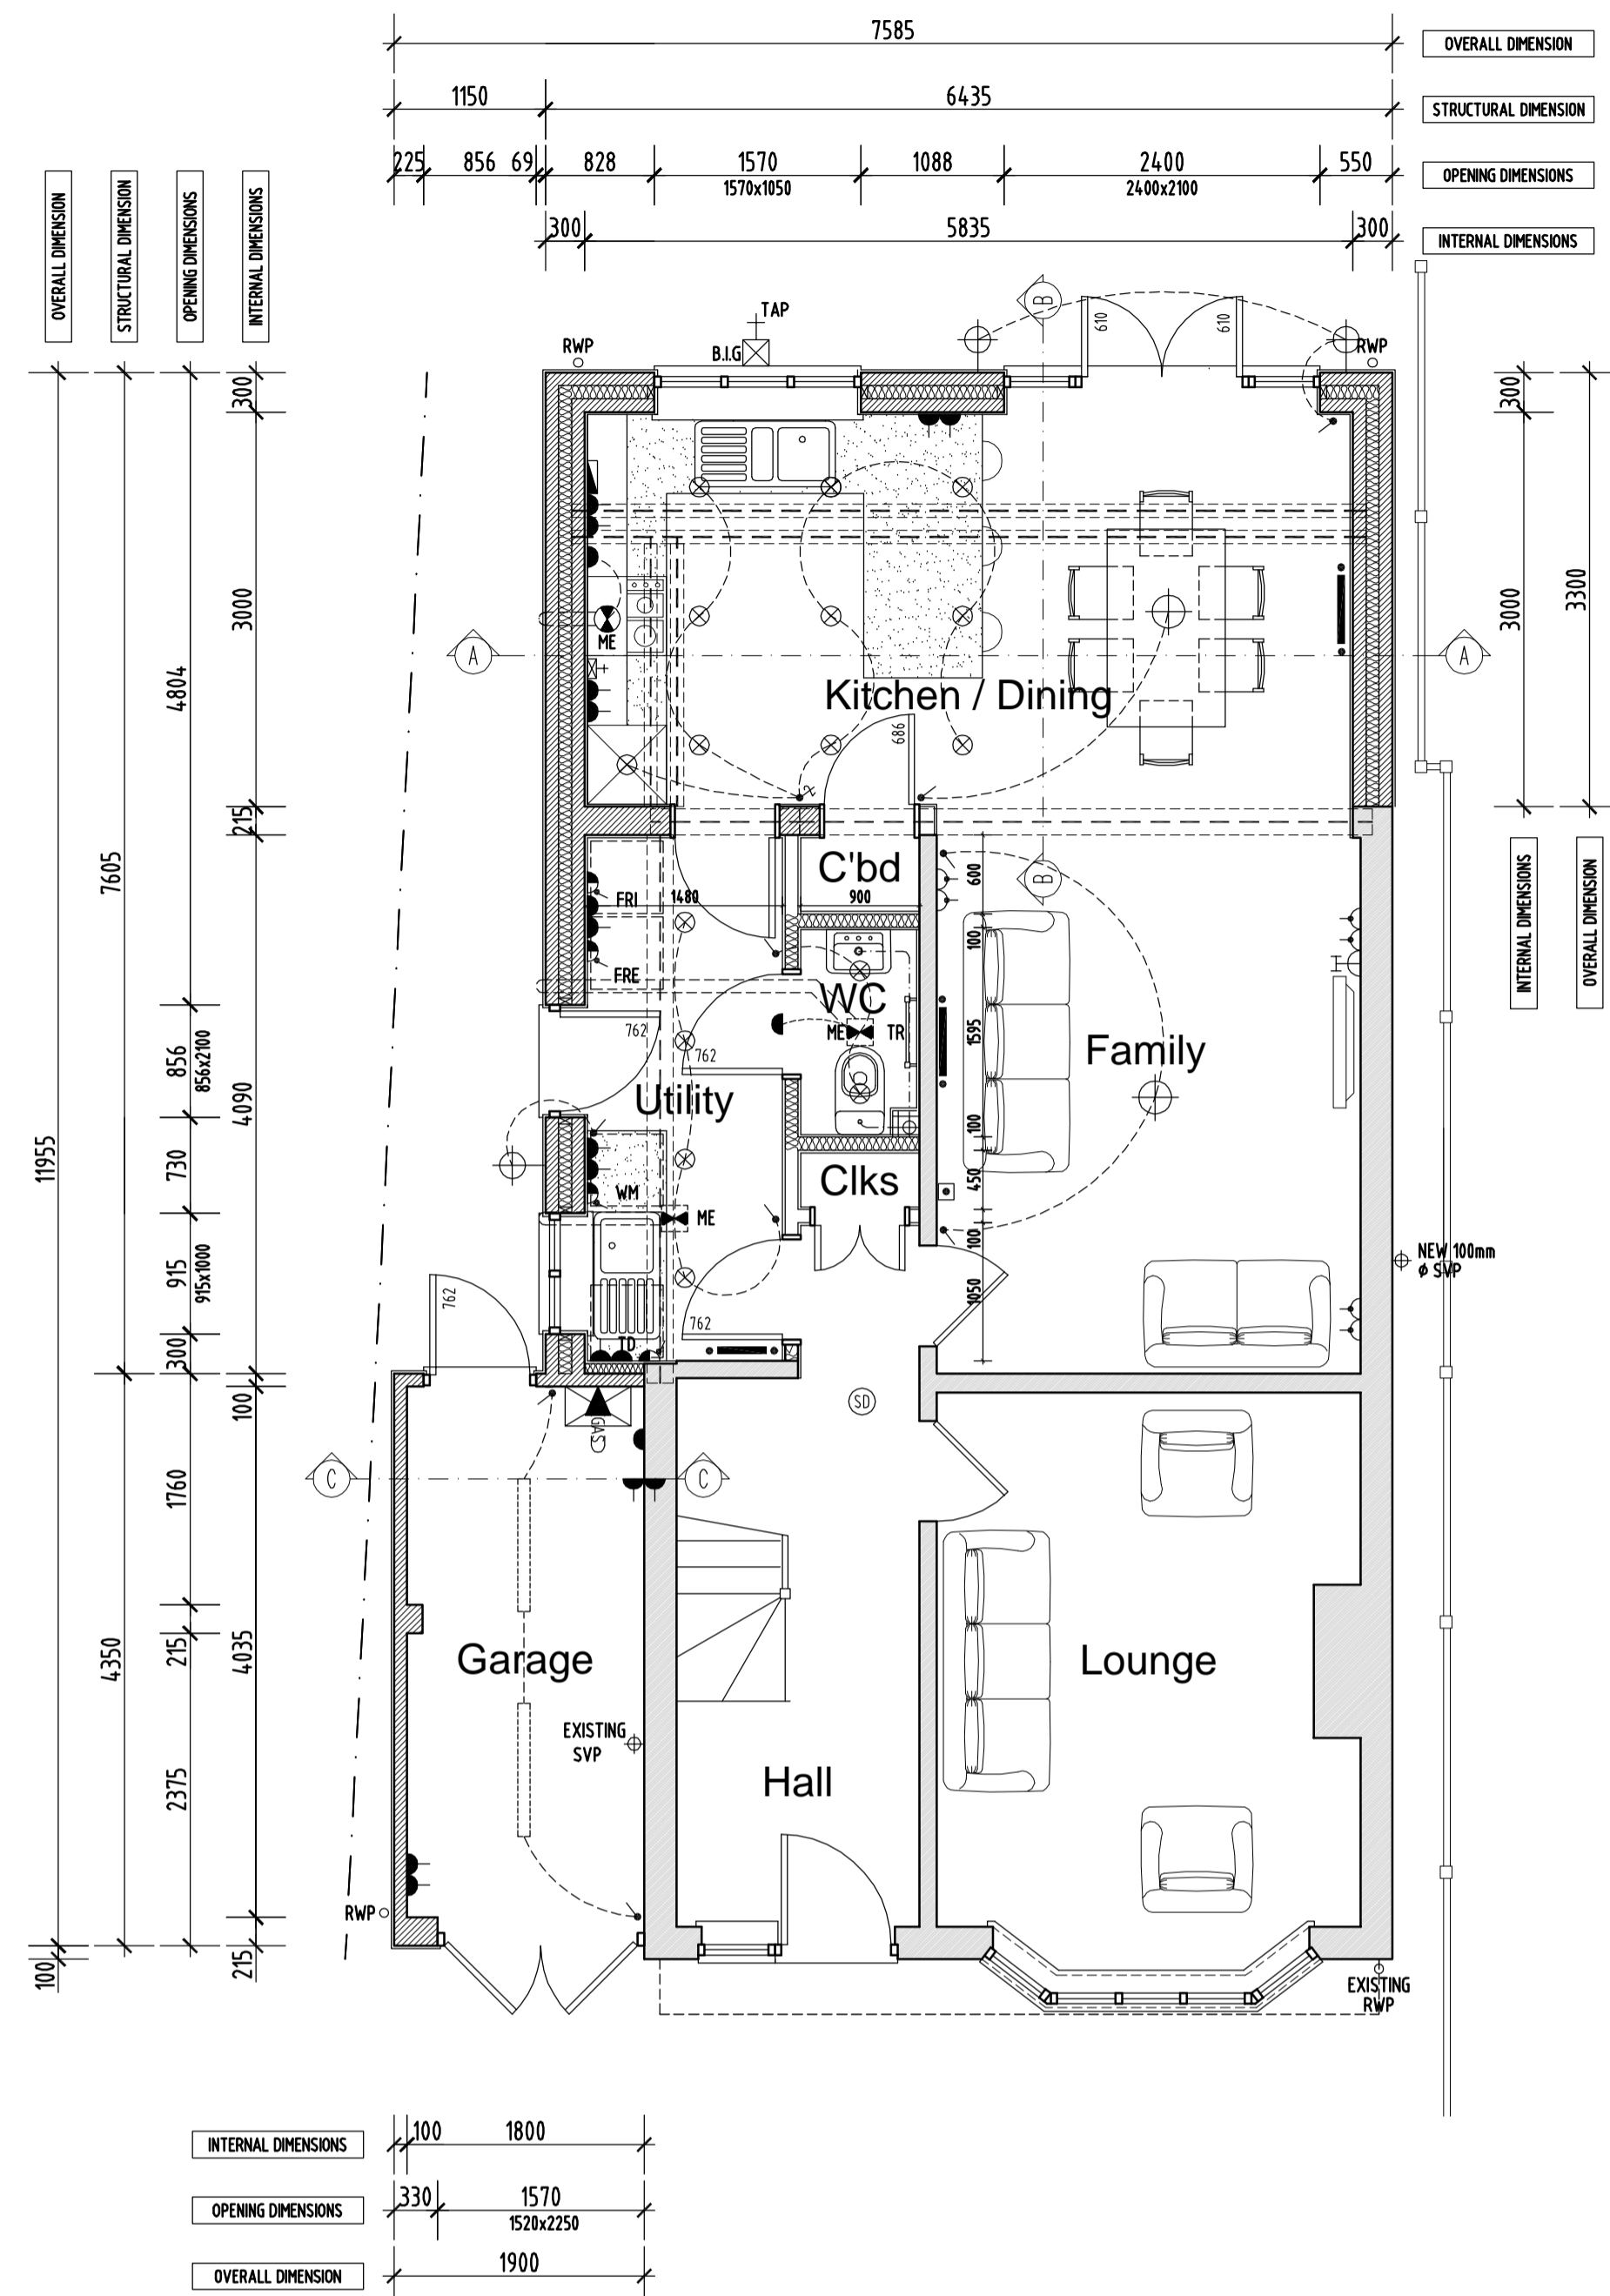

Ground floor plan

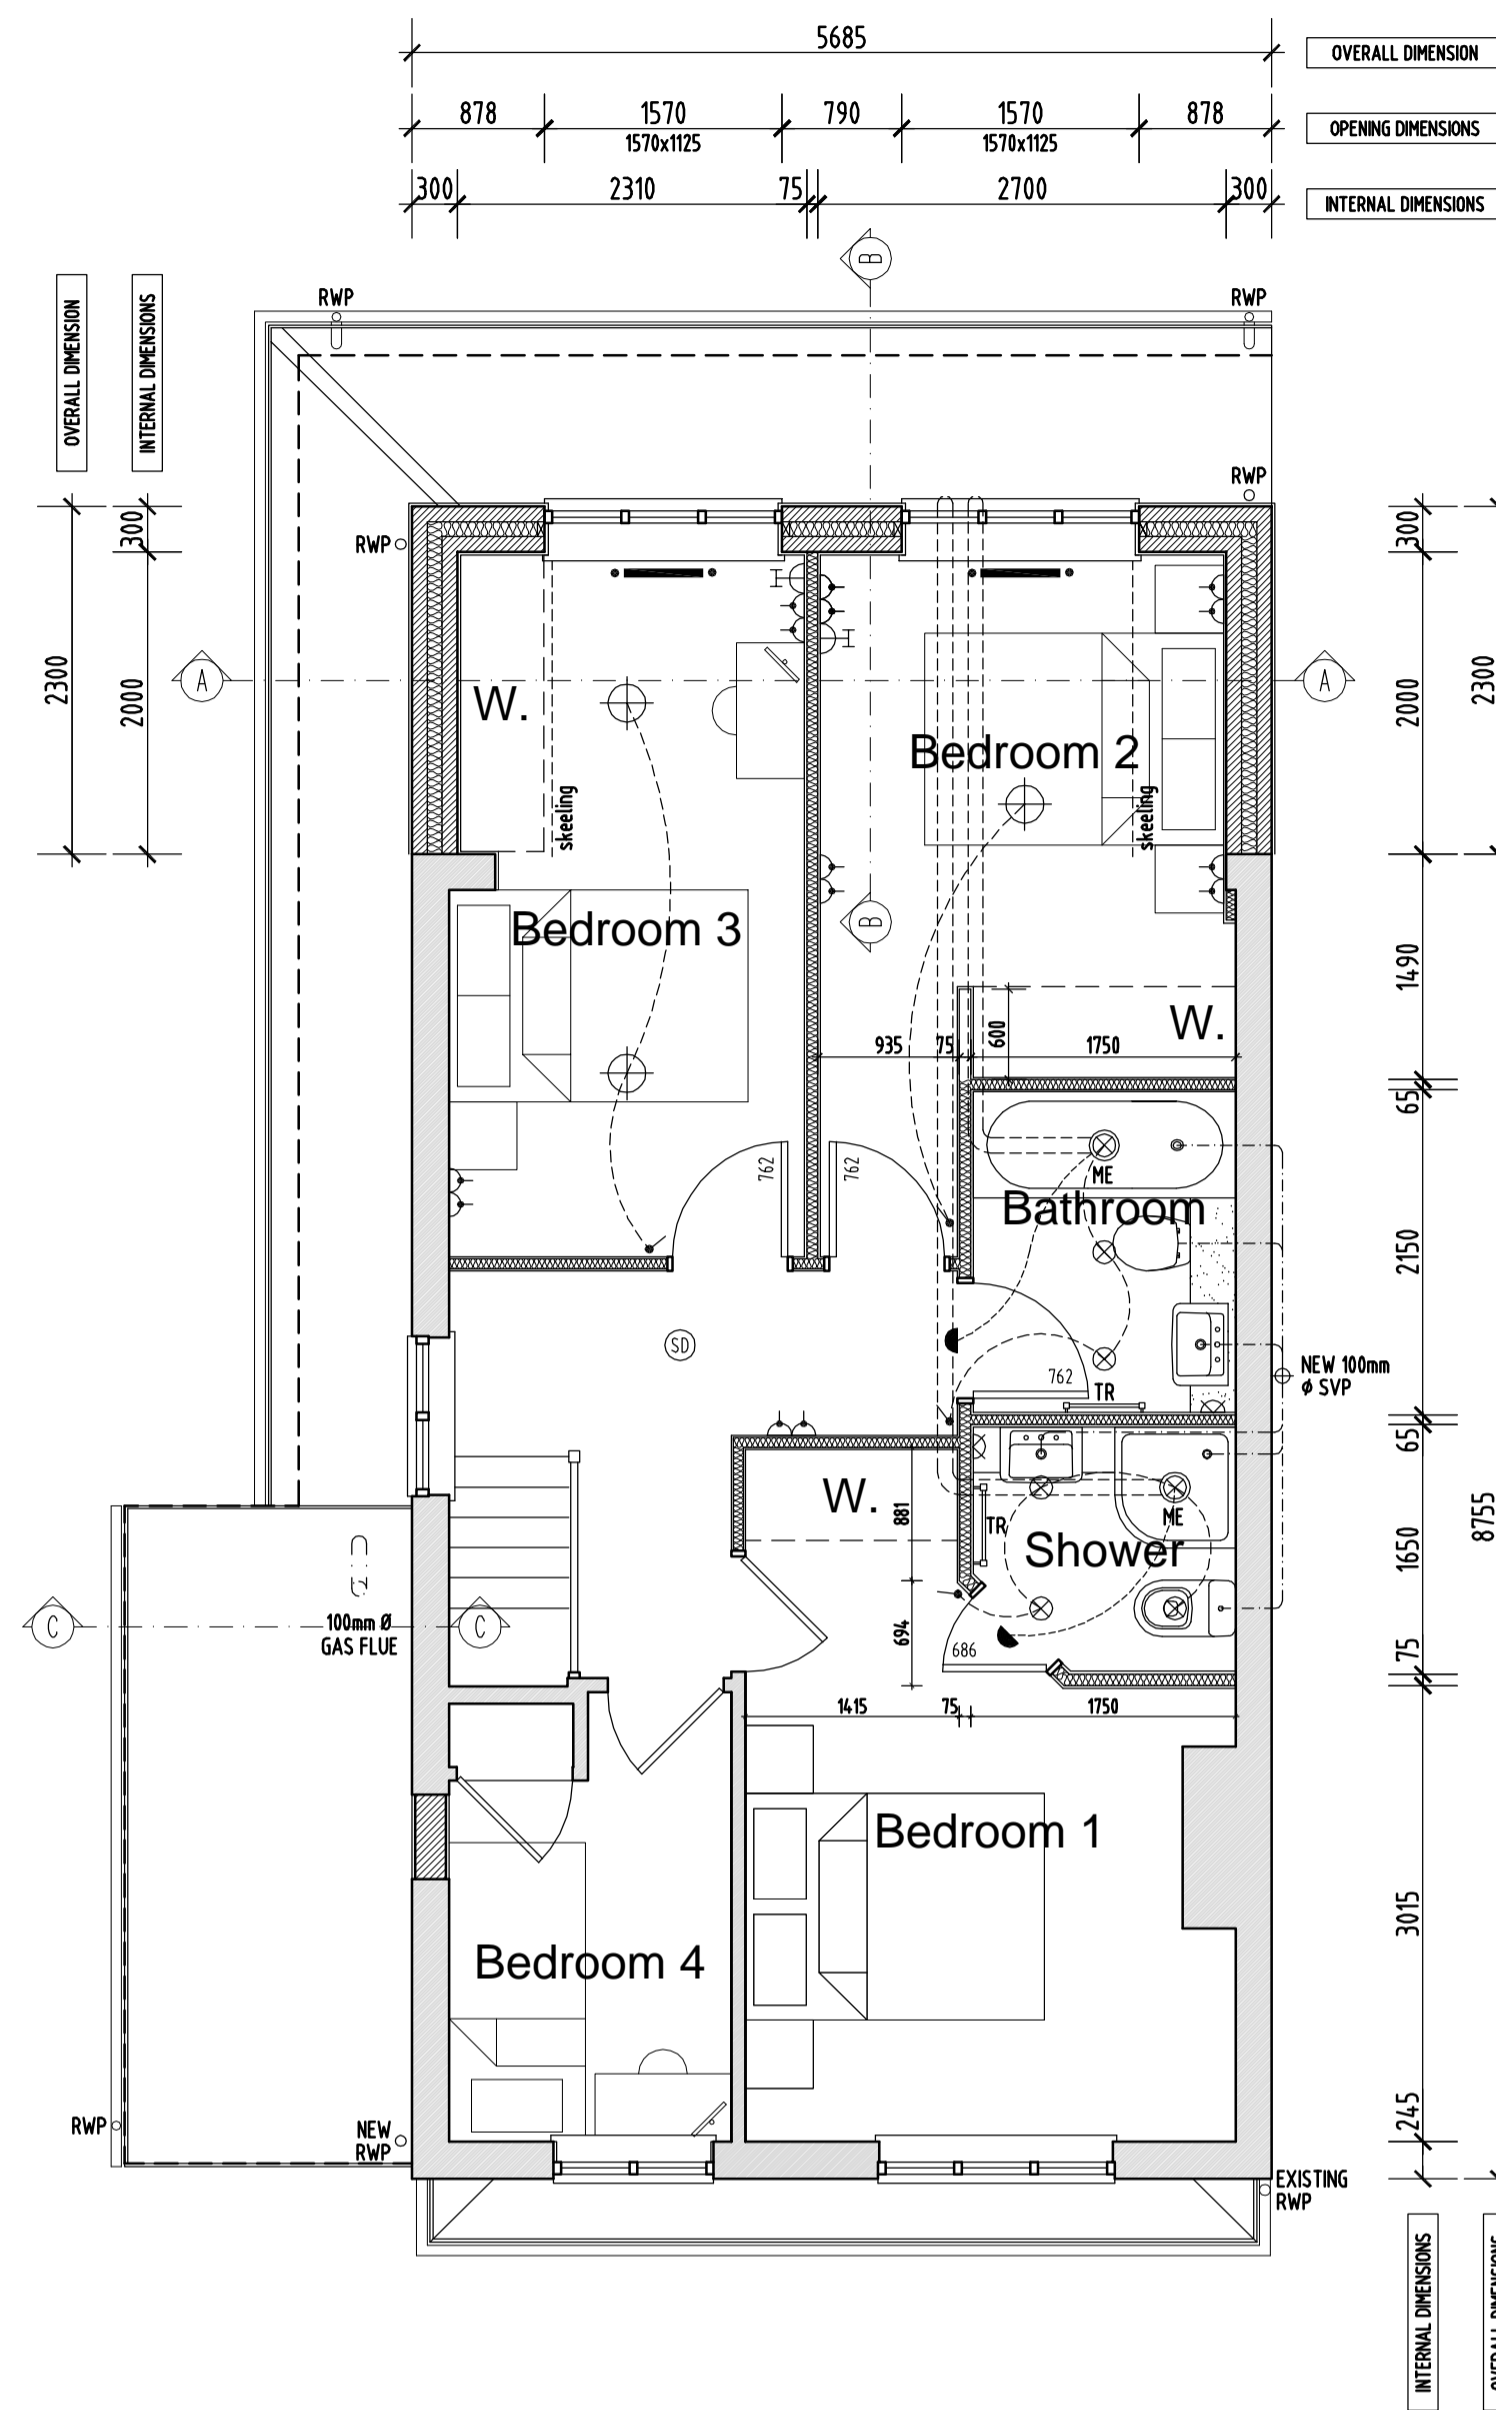

First floor plan

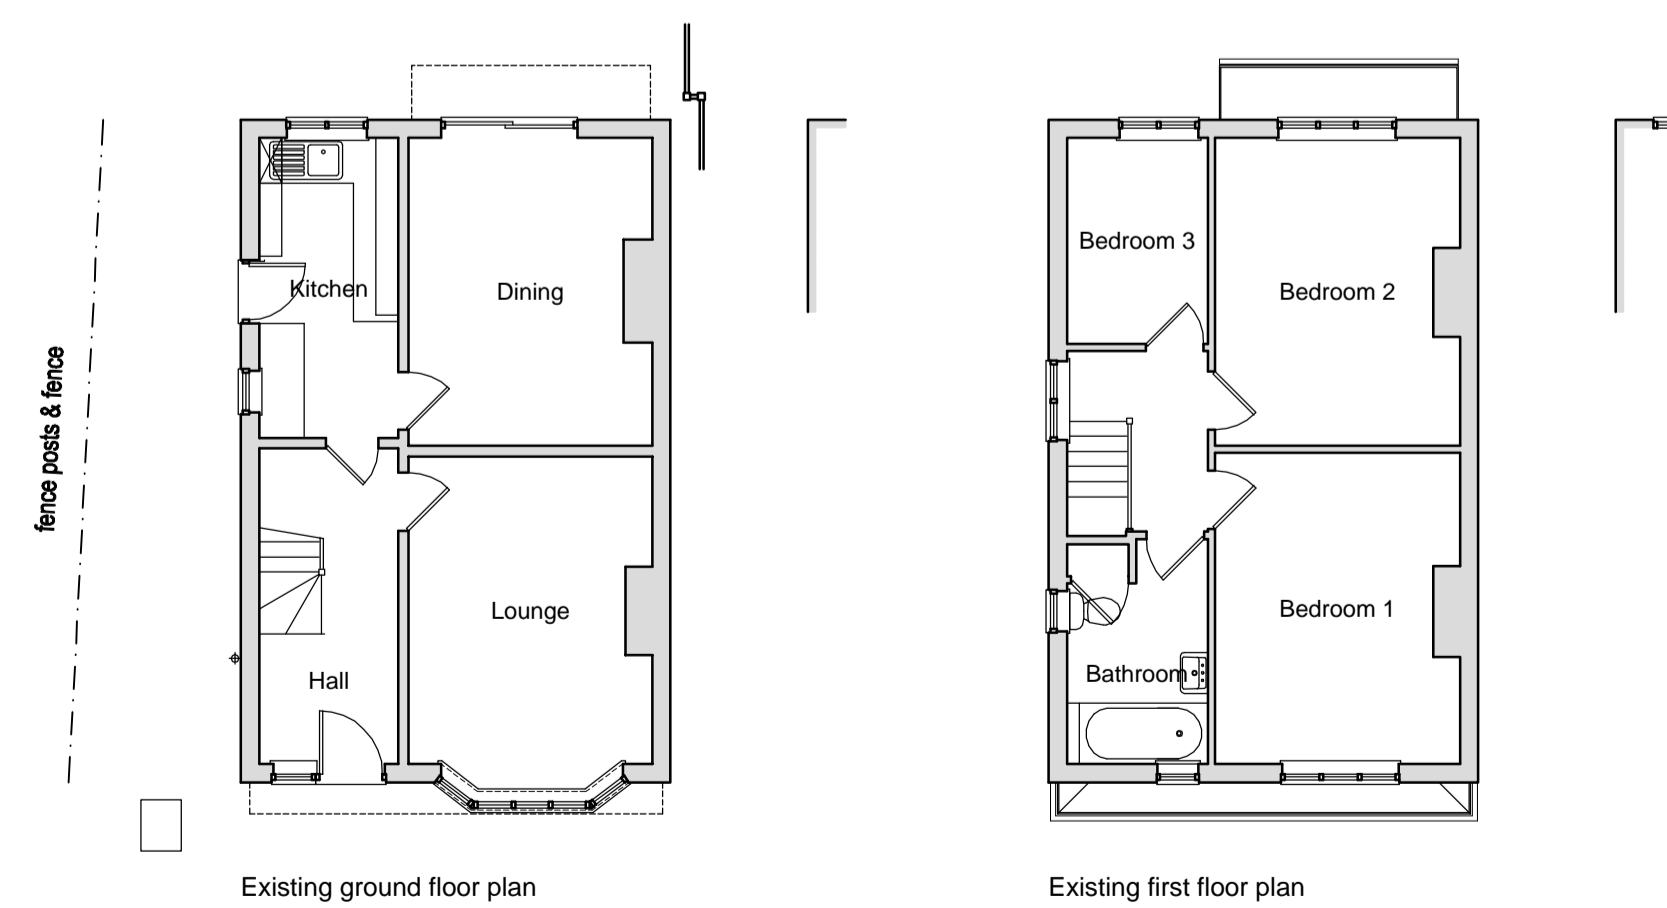

Existing ground floor plan

Existing first floor plan

ELECTRICAL LEGEND	
	PENDANT LAMP FITTING
	EXTERNAL LIGHT
	DOWNLIGHTER
	5 AMP SOCKET OUTLET
	EMERGENCY LIGHTING
	FLUORESCENT LIGHTING
	LIGHT SWITCH
	PULL CORD SWITCH
	DOUBLE SWITCHED OUTLET
	DOUBLE SWITCHED OUTLET ABOVE WORKTOP
	FUSED SPUR
	SWITCHED SPUR
	SWITCH ABOVE WORKTOP - SOCKET OUTLET BELOW
	SHAVER POINT
	TV AERIAL SOCKET
	COOKER CONTROL UNIT
	EXTRACTOR FAN - COOKER HOOD
	EXTRACTOR FAN - CEILING MOUNTED WITH AN IN-LINE FAN
	EXTRACTOR FAN INTEGRATED WITHIN DOWNLIGHTER
	IMMERSION HEATER WITH NEON INDICATOR - PROVIDE FUSED SPURS AS REQUIRED WITHIN THE CUPBOARD
	TELEPHONE SOCKET
	ILLUMINATED BELL PUSH
	ROOM THERMOSTAT
	SMOKE DETECTOR
	CONSUMER UNIT
	DOOR BELL
	GAS POINT
	PROGRAMMER
	KICKSPACE HEATER
	RADIATOR
	INFRA-RED SENSOR
	ENTRY PHONE

Rev.	Date	Details
Client		
Site		Drawing Title
Date	Scale 1:50 @ A1	
Drawn	Checked	
Drawing No.		