



FLOOR PLAN

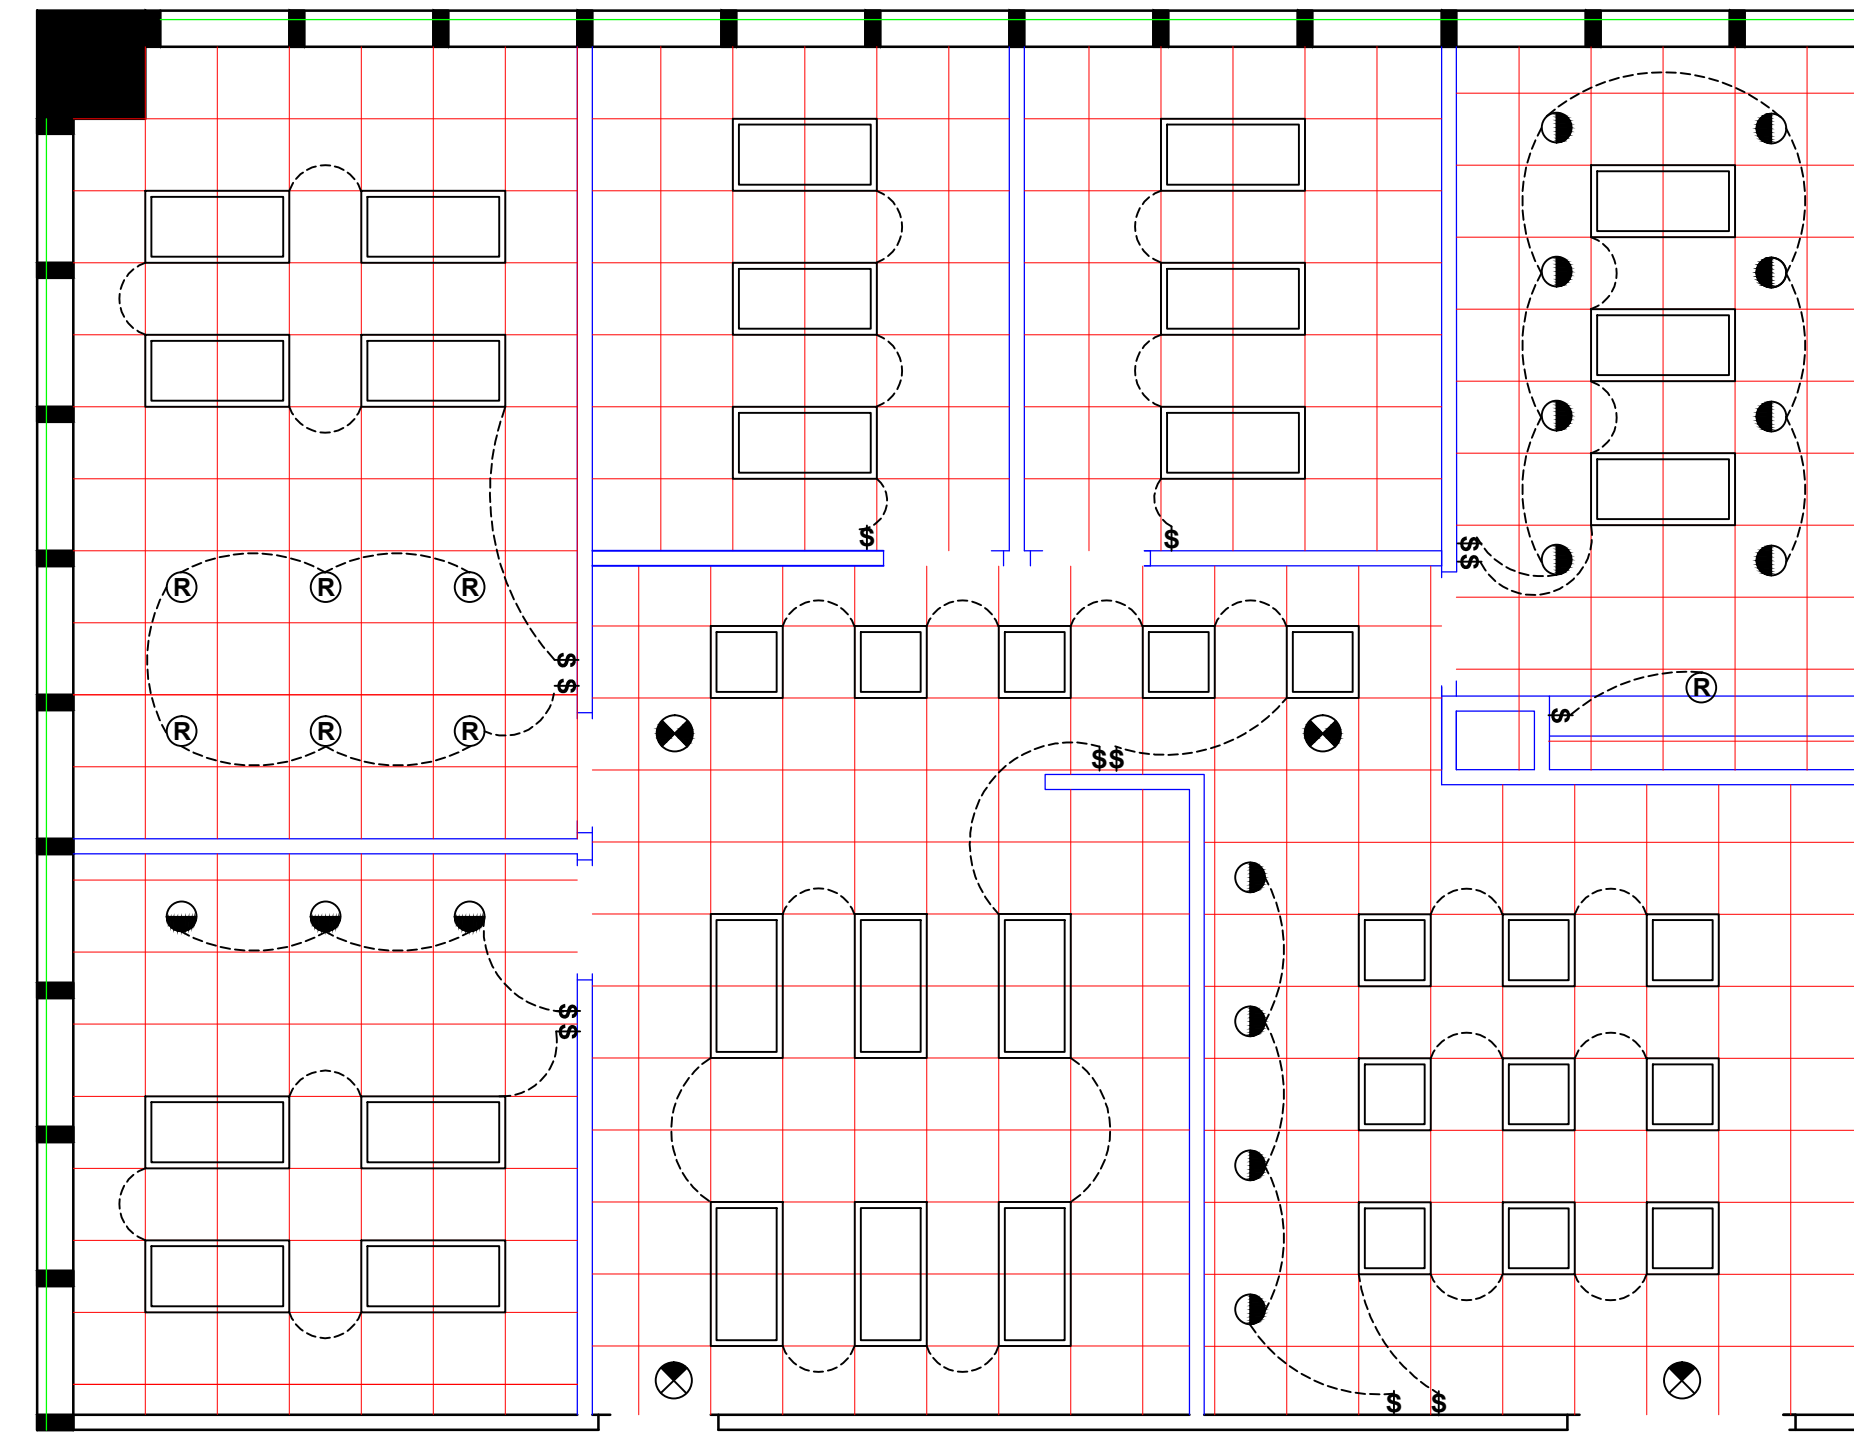


REFLECTED CEILING PLAN

- LIGHTING LEGEND**
- | SYMBOL | DESCRIPTION |
|-----------------|---|
| [Square] | 2' X 2' RECESSED FLUORESCENT FIXTURE |
| [Rectangle] | 2' X 4' RECESSED FLUORESCENT FIXTURE |
| (R) | 10" D. RECESSED INCANDESCENT DOWN LIGHT |
| (Circle) | 10" D. RECESSED INCANDESCENT WALLWASH |
| (Circle with X) | EXIT LIGHT |
| (Circle with S) | SHADED AREAS DENOTE SWITCH |

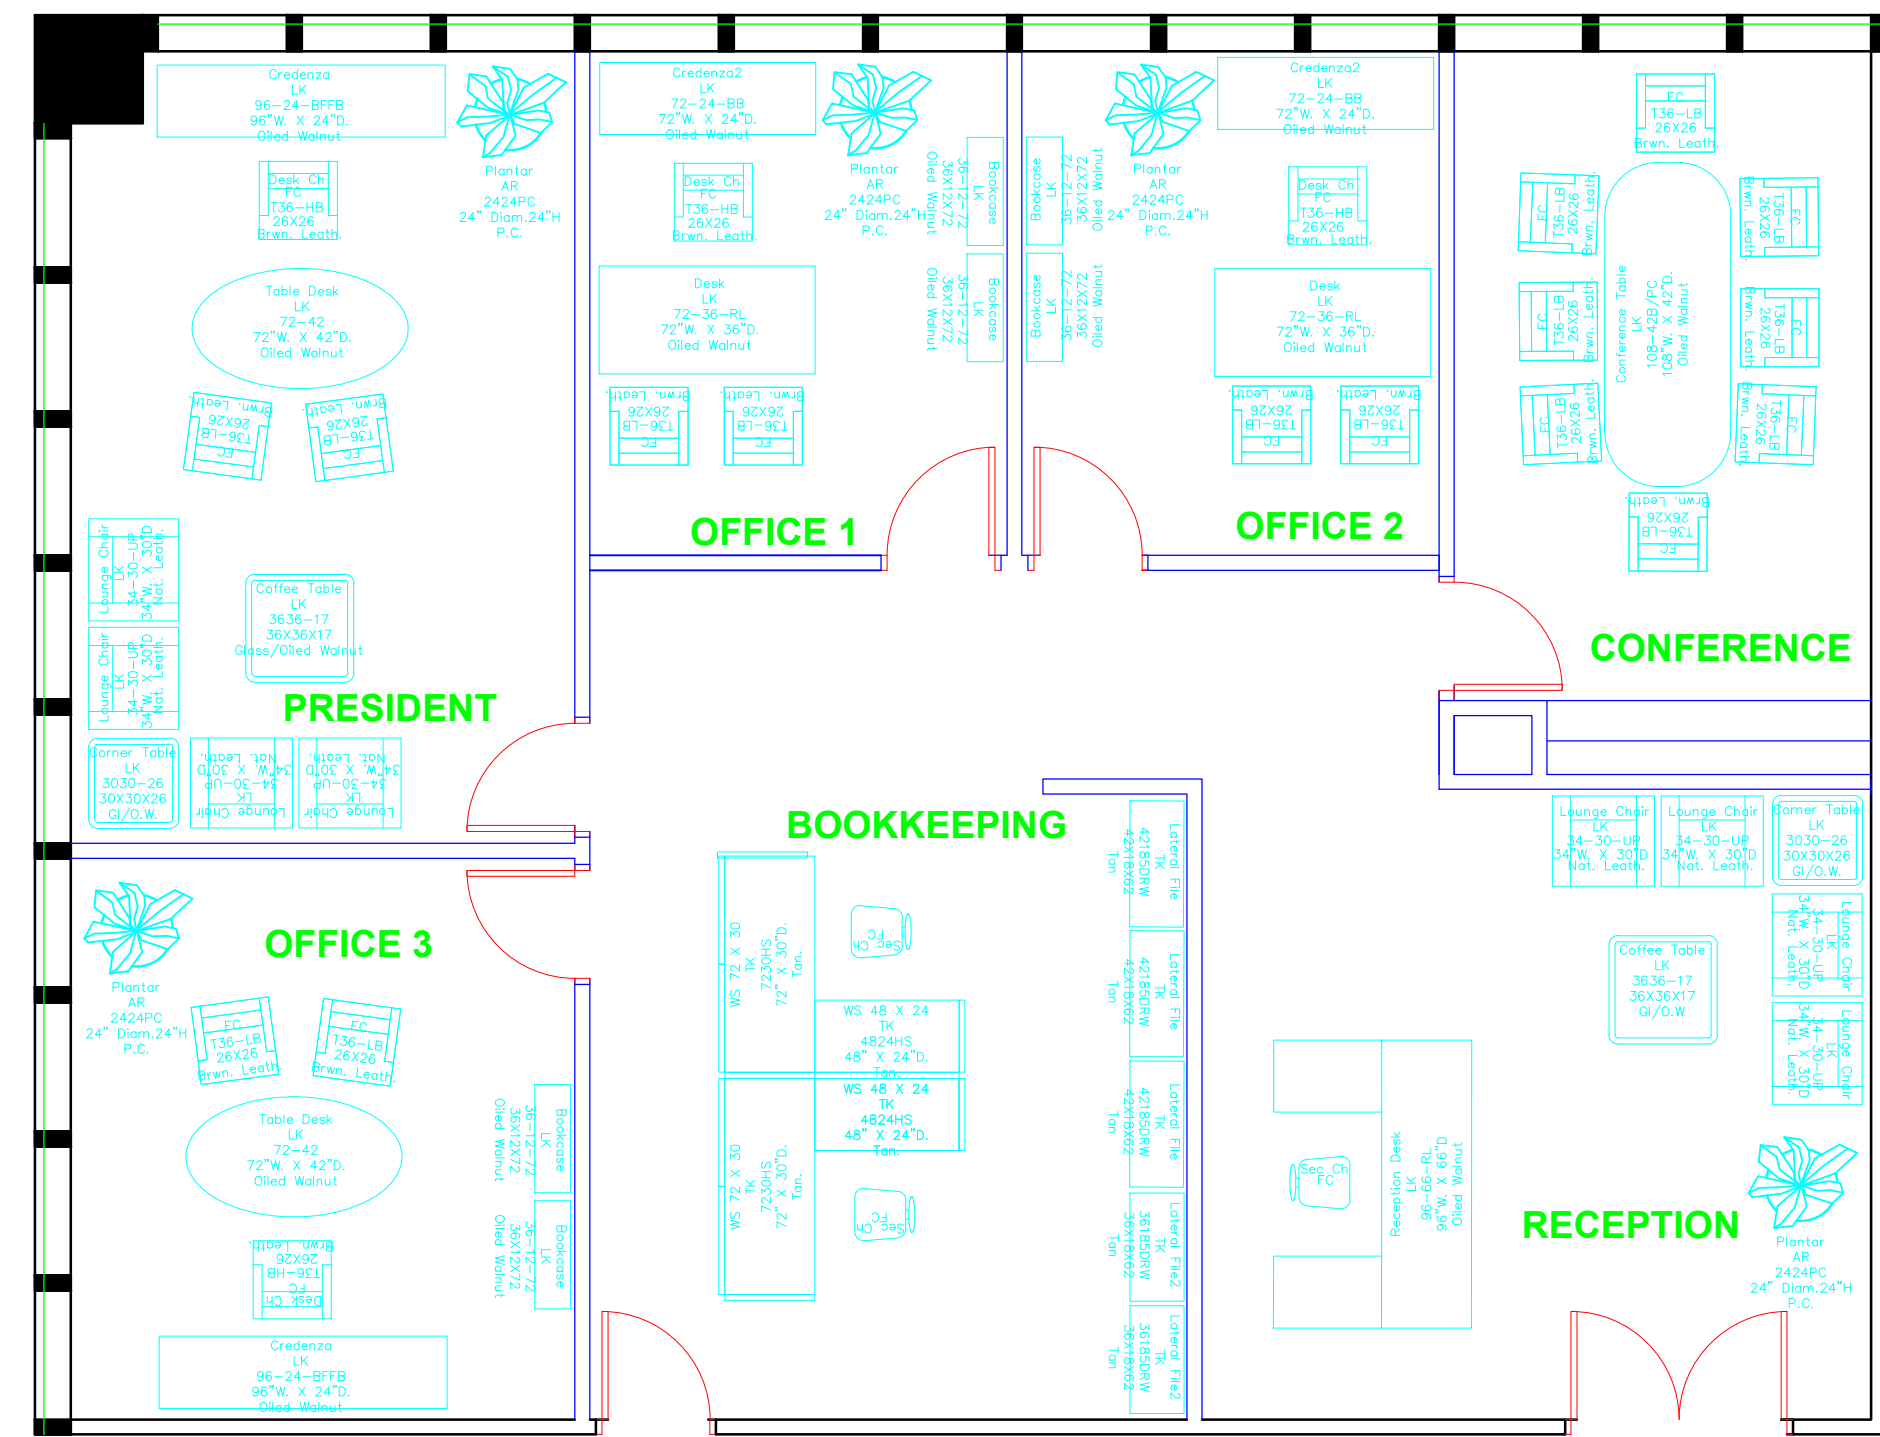

FURNITURE INSTALLATION PLAN

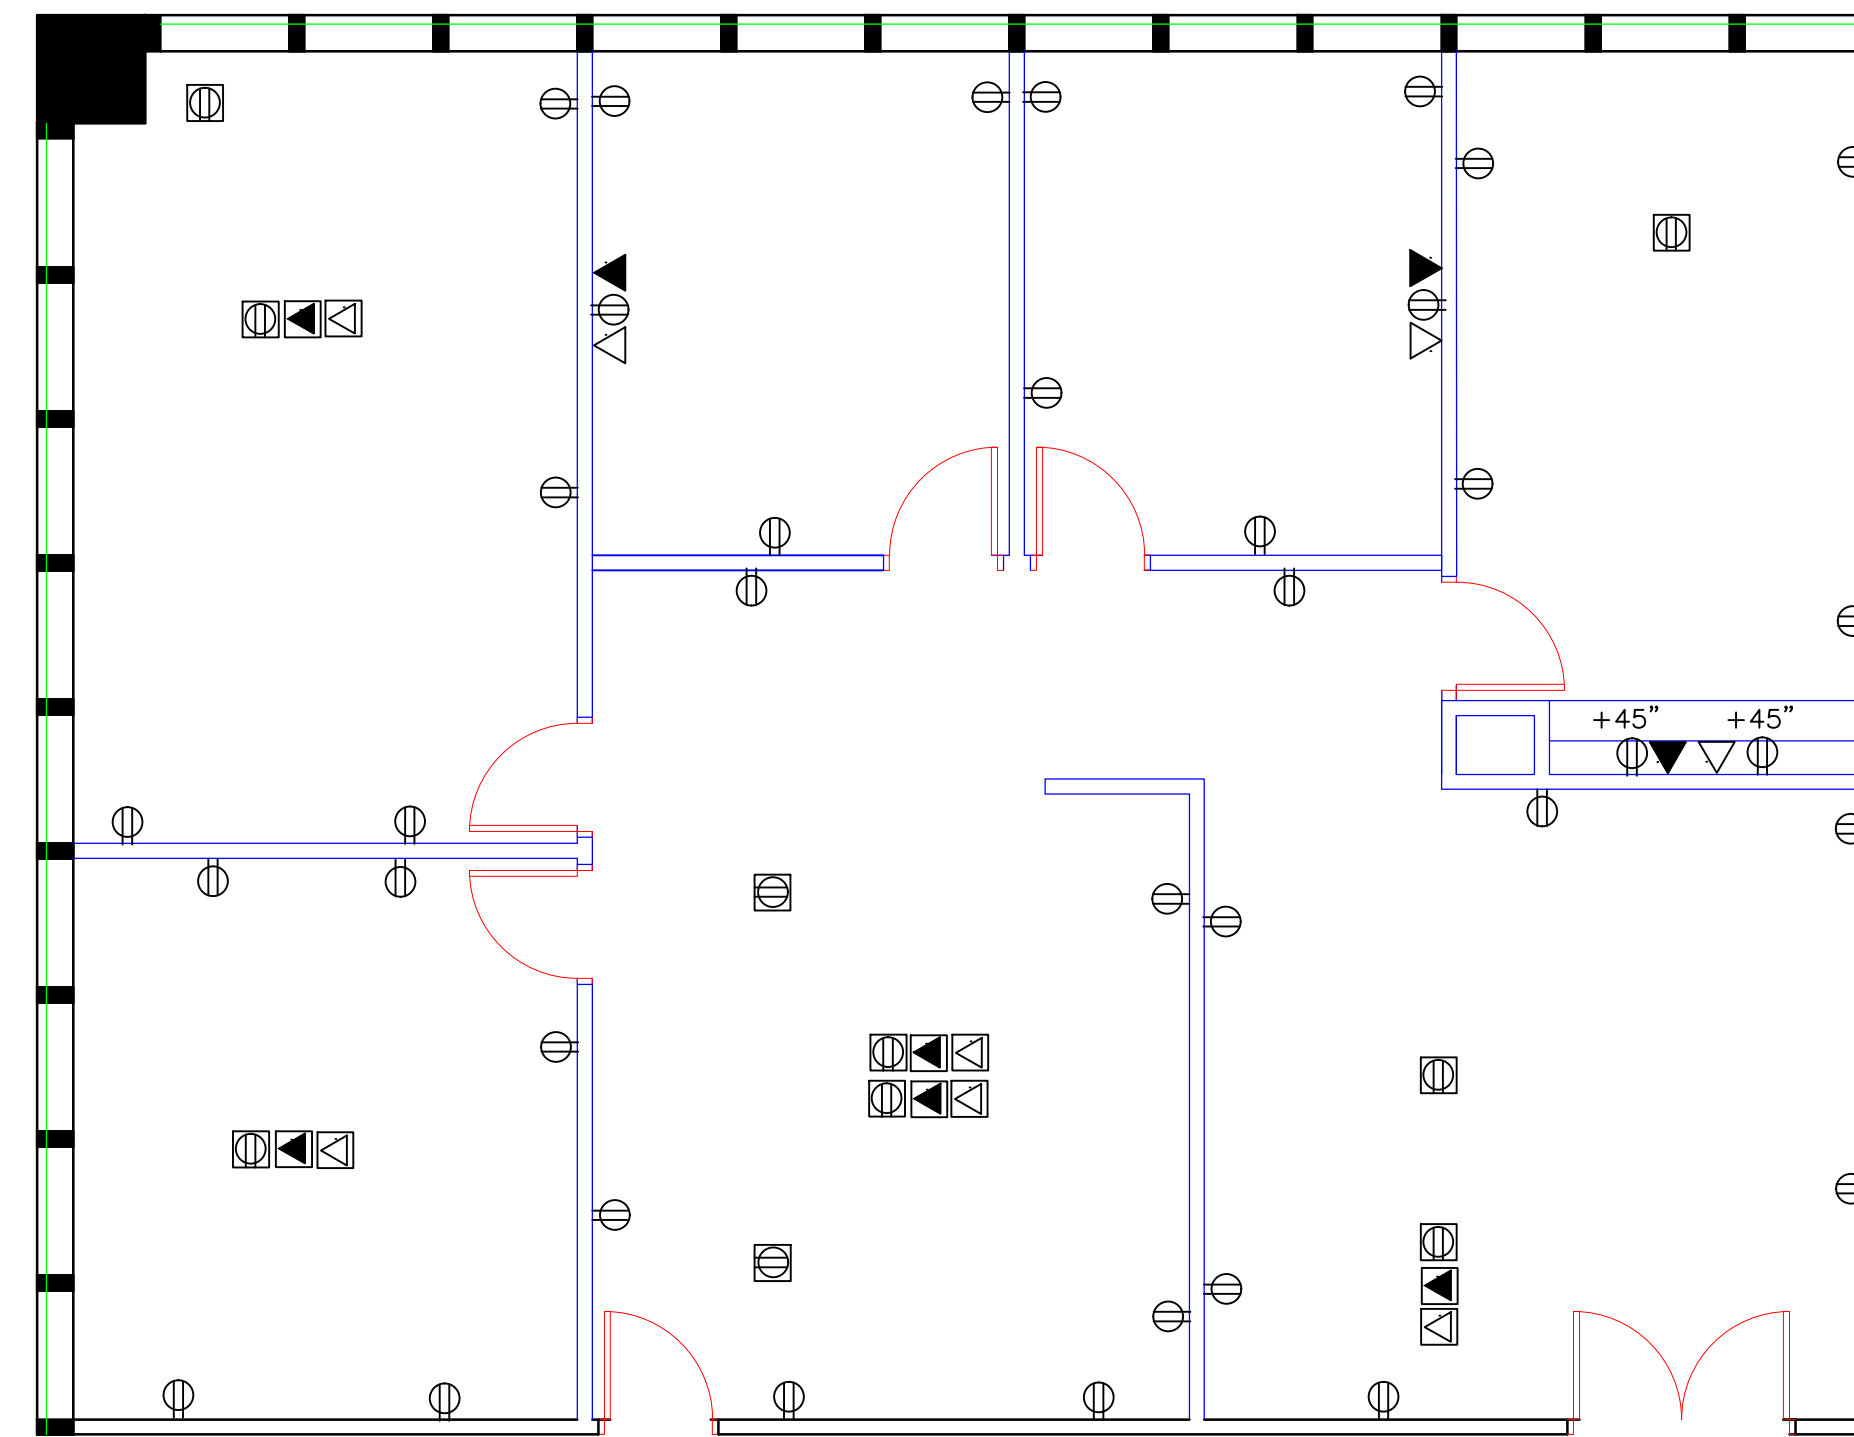

VOICE/DATA/POWER PLAN

- VOICE/DATA/POWER LEGEND**
- | SYMBOL | DESCRIPTION |
|----------|-------------------------|
| [Square] | TELEPHONE OUTLET |
| [Square] | FLOOR TELEPHONE OUTLET |
| [Square] | DATA OUTLET |
| [Square] | FLOOR DATA OUTLET |
| (Circle) | DUPLEX RECEPTACLE |
| (Square) | FLOOR DUPLEX RECEPTACLE |

TENANT SPACE

General Notes

No.	Revision/Issue	Date

Firm Name and Address
 Leah Tessier
 IDES 240: 740
 MSU

Project Name and Address
 PRESENTATION

Project CH12-TUTORIAL1	Sheet
Date 03/31/2011	1 of 1
Scale 3/16"=1'-0"	