






**1 PERSPECTIVE**  
SCALE: NTS

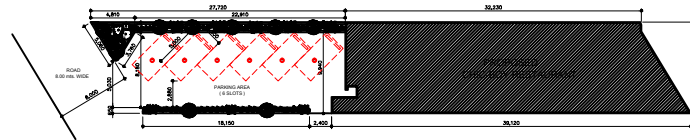

**2 SITE DEVELOPMENT PLAN**  
SCALE: 1:300 METERS

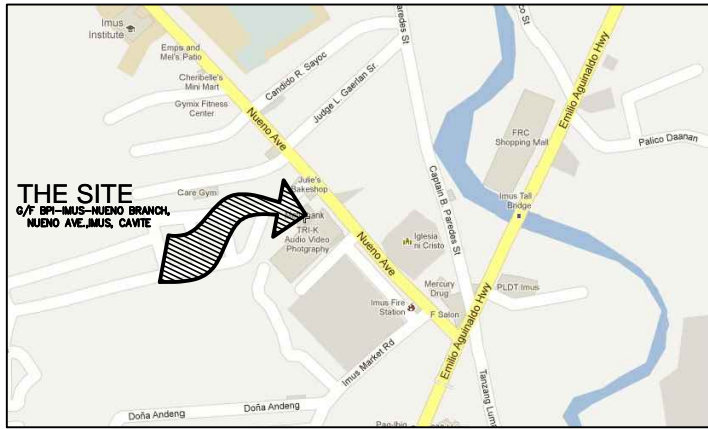

**3 LOCATION PLAN**  
SCALE: NTS

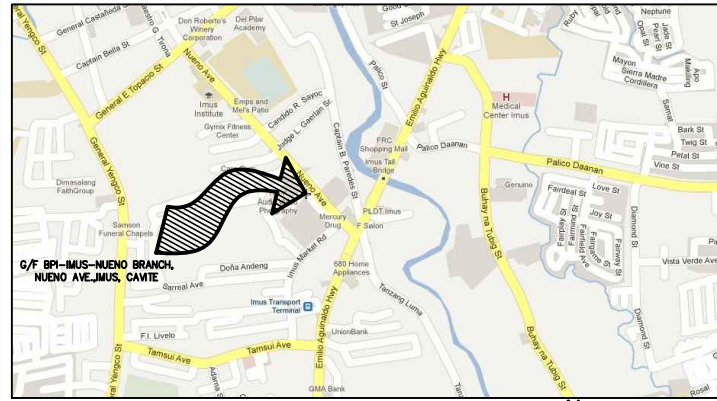

**4 VICINITY MAP**  
SCALE: NTS

TABLE OF CONTENTS		Republic of the Philippines Department of Public Works and Highways OFFICE OF THE BUILDING OFFICIAL	
ARCHITECTURAL		District/City/Municipality	
A-1	TABLE OF CONTENTS		
	VICINITY MAP		
	LOCATION PLAN		
	PERSPECTIVE		
	SITE DEVELOPMENT PLAN		
A-2	AS-BUILT/DEMOLITION PLAN		LAND USE & ZONING
	FURNITURE LAYOUT		
A-3	SETTING-OUT PLAN		
	REFLECTED CEILING PLAN		
A-4	FRONT ELEVATION		LINE & GRADE
	SECTIONAL ELEVATIONS		
	CEILING DETAILS		
A-5	DROP CEILING DETAILS		
A-6	DOORS AND WINDOW SCHEDULE	ARCHITECTURAL	
	DOOR JAMB DETAILS		
A-7	STANDARD MOUNTING HEIGHTS		
A-8	TAB DETAILS		
	JANITORIAL DETAILS/MOP SINK	STRUCTURAL	
	MIRROR DETAILS		
	SPOT DETAILS		
	WATER'S STATION DETAILS		
A-9	POS COUNTER DETAILS		
A-10	DETAILS OF PASS-THRU COUNTER		
	DETAILS OF TAKE-OUT COUNTER		
	DETAILS OF EMPLOYEE'S LOCKER		
A-11	PORTAL DETAILS		
	LPO CAGE DETAILS		
PLUMBING / SANITARY			ELECTRICAL
P-1	GENERAL NOTES		
	PLUMBING LEGEND		
	STANDARD PIPE DETAILS		
P-2	COLD WATER LINE LAYOUT		
	SANITARY LINE LAYOUT		
P-3	ISOMETRIC COLD WATERLINE LAYOUT		
	ISOMETRIC SANITARY LINE LAYOUT		
GL-1	GENERAL NOTES & LEGEND		
	GASLINE LAYOUT		
	GASLINE ISOMETRIC LAYOUT		
FS-1	SUPPRESSION SYSTEM DETAILS	PLUMBING	
ELECTRICAL			
E-1	LOAD SCHEDULE & COMPUTATION		
	GENERAL NOTES		
	LEGENDS & ABBREVIATIONS		
	VICINITY MAP/LOCATION PLAN		
	POWER RISER DIAGRAM		
	PANEL DETAIL		
E-2	POWER LAYOUT		
	LIGHTING LAYOUT		
	AUXILIARY LAYOUT		
	NOTES	MECHANICAL	
	SWITCH BANK DETAIL		
MECHANICAL			
M-1	LEGENDS & SYMBOLS		
	EQUIPMENT SCHEDULE		
	MISCELLANEOUS DETAILS		
	GENERAL NOTES & SPECIFICATIONS		
M-2	AIR-CONDITIONING LAYOUT		
	EXHAUST & FRESH AIR LAYOUT		

**RBTOLentino & ALLIED ENGINEERS**  
0947 2803741 / 0928 272 5293  
8000 2107 24 PICTA COMUNITARIES  
NEW CABALAN, OLONGAPO CITY

ARCHITECT:  
**RODEL B. TOLentino**

PROJECT TITLE:  
**PROPOSED CHICBOY RESTAURANT  
NUENO AVE.,  
IMUS, CAVITE**

SHEET CONTENTS:  
- TABLE OF CONTENTS  
- LOCATION PLAN  
- VICINITY MAP  
- PERSPECTIVE

OWNER:  
\_\_\_\_\_

NOTE:  
- ALL DIMENSIONS UNLESS OTHERWISE SPECIFIED ARE IN METERS.  
- ALL DIMENSIONS ARE TO FACE UNLESS OTHERWISE SPECIFIED.  
- ALL DIMENSIONS ARE TO FACE UNLESS OTHERWISE SPECIFIED.  
- ALL DIMENSIONS ARE TO FACE UNLESS OTHERWISE SPECIFIED.  
- ALL DIMENSIONS ARE TO FACE UNLESS OTHERWISE SPECIFIED.

SHEET NO.:  
**A-1**  
1/11

TIN: <b>28234068</b>	REG. NO: <b>0022618</b>	DRAWN BY: <b>KDC</b>	DATE: <b>02-13-2012</b>	RES. CERT. NO: _____	DATE: _____
PR. NO: <b>0225740</b>	DATE/LOCATION: <b>02-07-12/OLONGAPO CITY</b>	CHECKED BY: <b>MBT</b>	DATE: <b>02-13-2012</b>	THE	LOCATION: _____

THE COPYRIGHT OF THIS DRAWING REMAINS THE PROPERTY OF RBT  
WHOSE PERMISSION MUST BE OBTAINED BEFORE ANY OF IT CAN BE MADE.