



LIGHTNING DESIGN

120 N. LOCUST ST  
REEDSBURG WI, 53959  
608-499-1352

THIS DRAWING MAY NOT BE REPRODUCED  
WITHOUT THE EXPRESSED WRITTEN  
CONSENT OF LIGHTNING DESIGN

STAMP

PROJECT NAME

HOUSE  
PLANS

DRAWN BY: \_\_\_\_\_  
CHECKED BY: \_\_\_\_\_  
DATE: \_\_\_\_\_  
PRINTED: \_\_\_\_\_


REV. NO.	REV. NAME	DESCRIPTION

DRAWING NAME  
**FRONT ELEVATION**

SCALE:  
**1/4" = 1'-0"**

DRAWING NUMBER

**A-5**

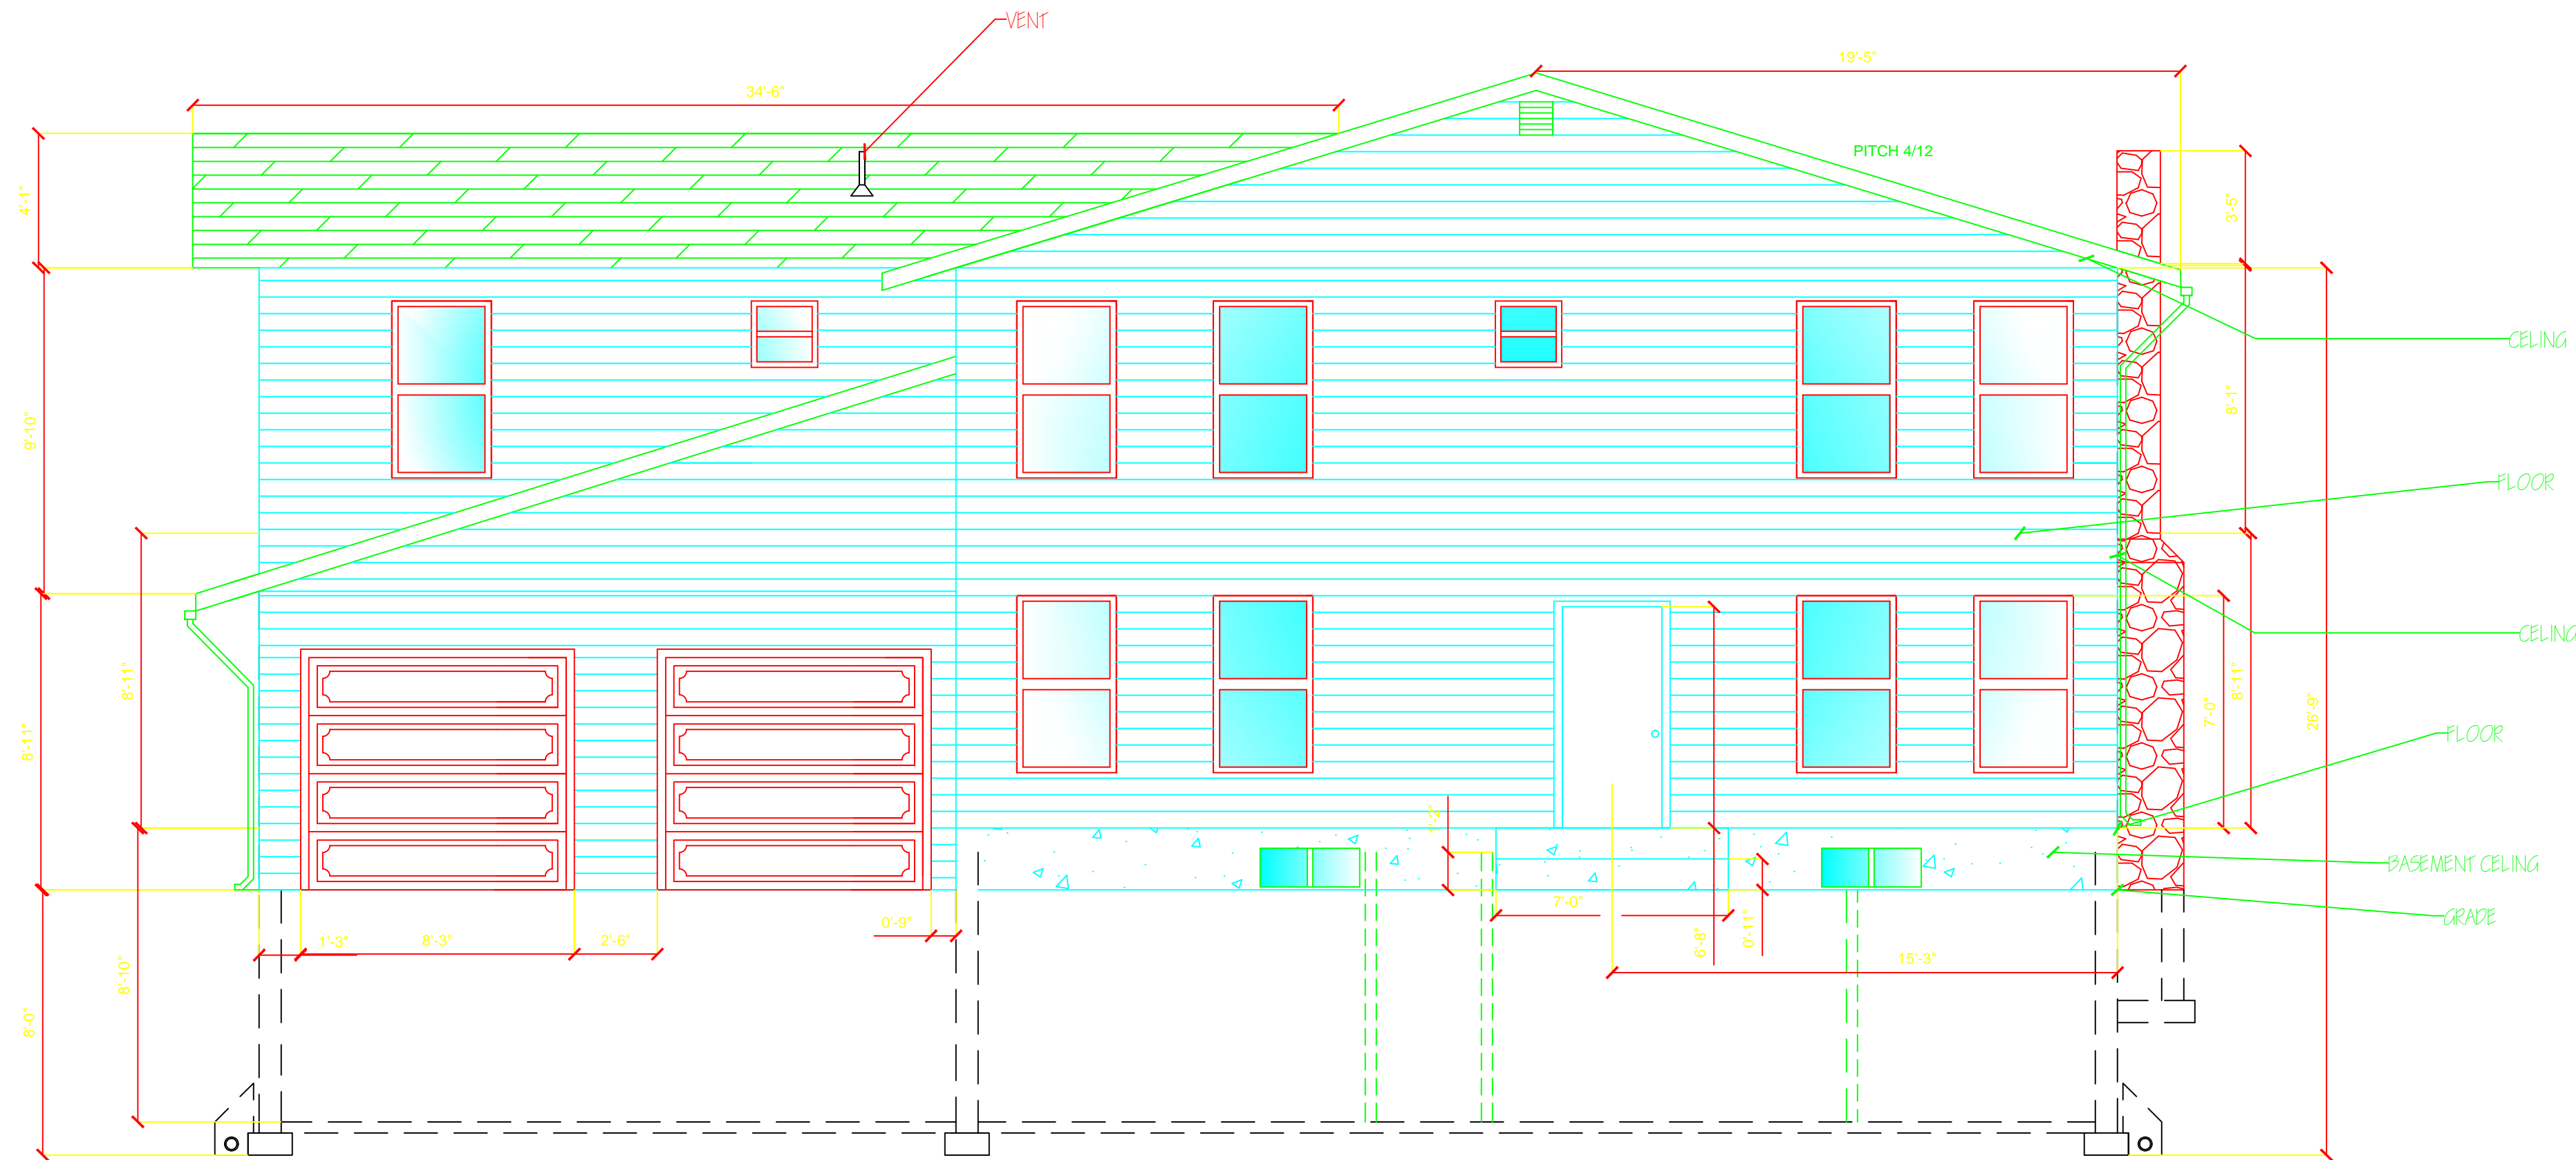

**FRONT ELEVATION  
LOOKING NORTH**

**SCALE: 1/4" = 1'-0"**