


LIGHTNING DESIGN

120 N. LOCUST ST
REEDSBURG WI, 53959
608-495-1352

THIS DRAWING MAY NOT BE REPRODUCED
WITHOUT THE EXPRESSED WRITTEN
CONSENT OF LIGHTNING DESIGN

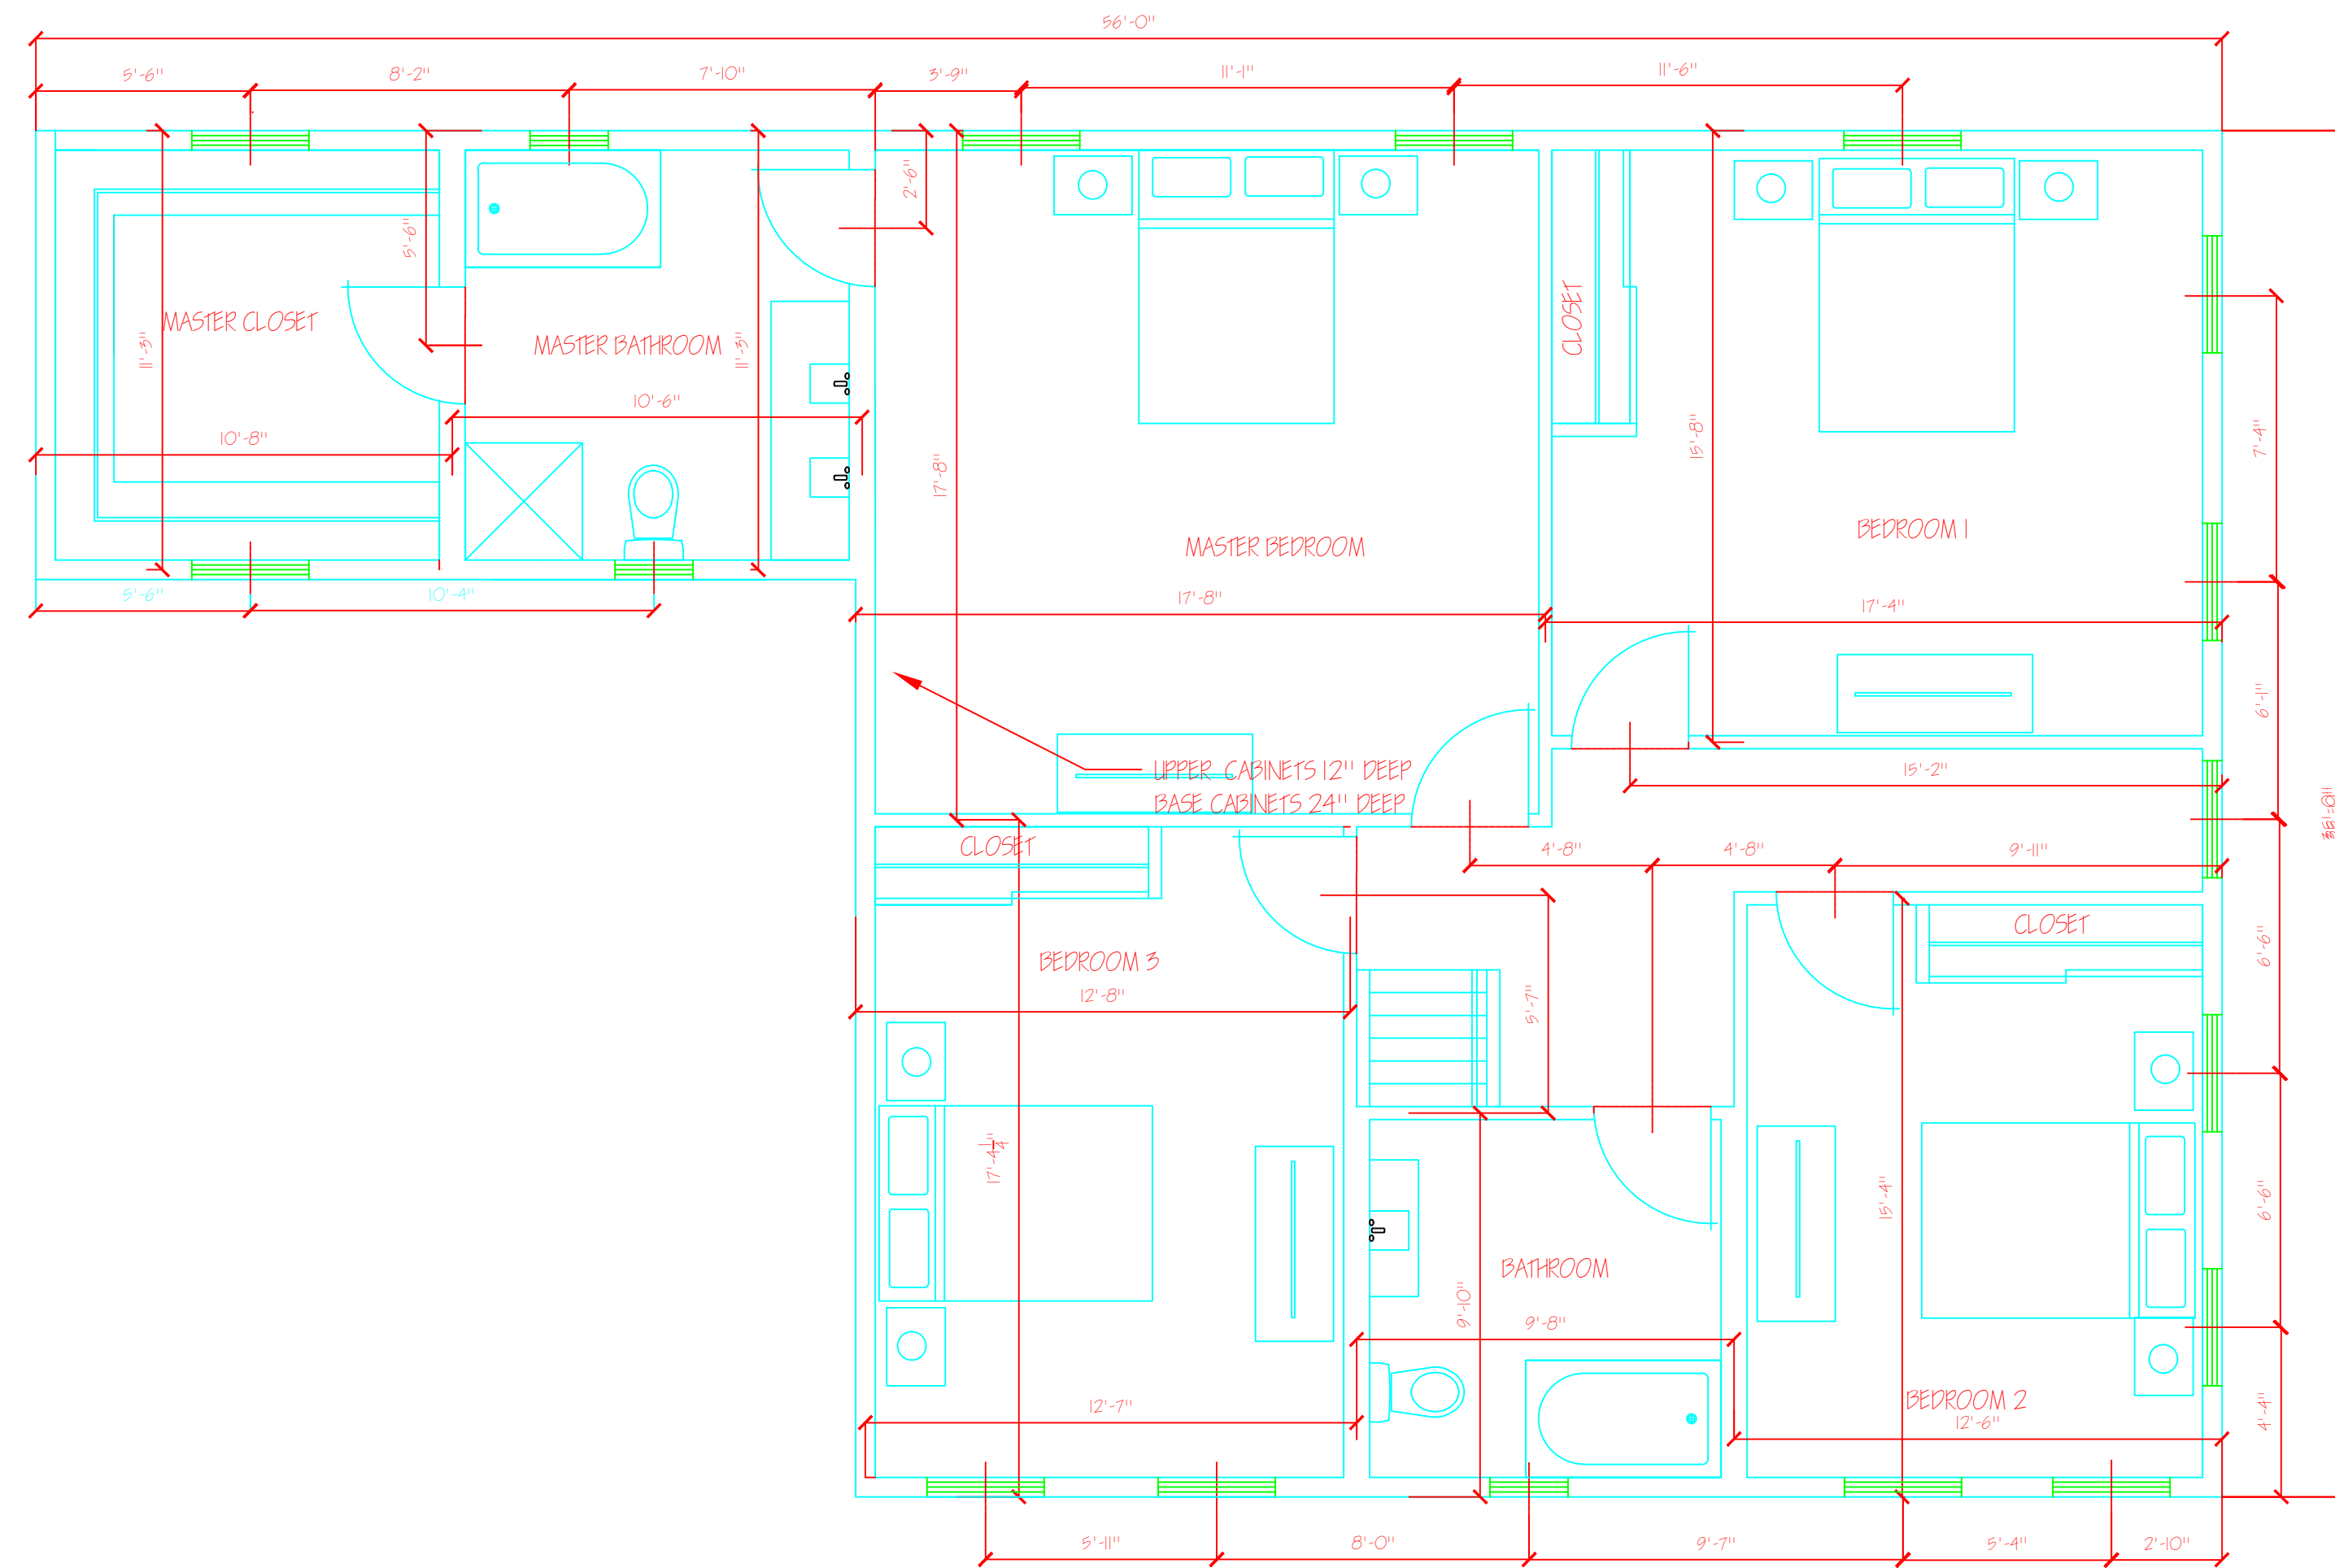

FLOOR PLAN SECOND FLOOR

1/4" = 1'-0"



HOUSE PLANS

DRAWN BY: Prandon Eichelstadt
CHECKED BY: _____
DATE: _____
PRINTED: _____

REV. NO.	REV. NAME	DESCRIPTION

PROJECT NAME
FLOORPLAN FIRST FLOOR

SCALE:
1/4" = 1'-0"

PROJECT NUMBER

A-1

OF _____