

LIGHTNING DESIGN

120 N. LOCUST ST  
REEDSBURG WI, 53959  
608-495-1352

THIS DRAWING MAY NOT BE REPRODUCED  
WITHOUT THE EXPRESSED WRITTEN  
CONSENT OF LIGHTNING DESIGN

DATE:

PROJECT:

# HOUSE PLANS

DRAWN BY: Prandon Eichelstadt  
CHECKED BY: \_\_\_\_\_  
DATE: \_\_\_\_\_  
PRINTED: \_\_\_\_\_

REV. NO.	REV. NAME	DESCRIPTION

DESCRIPTION:

FLOORPLAN FIRST FLOOR


SCALE:

1/4" = 1'-0"

PROJECT NUMBER:

# A-1

OF \_\_\_\_\_

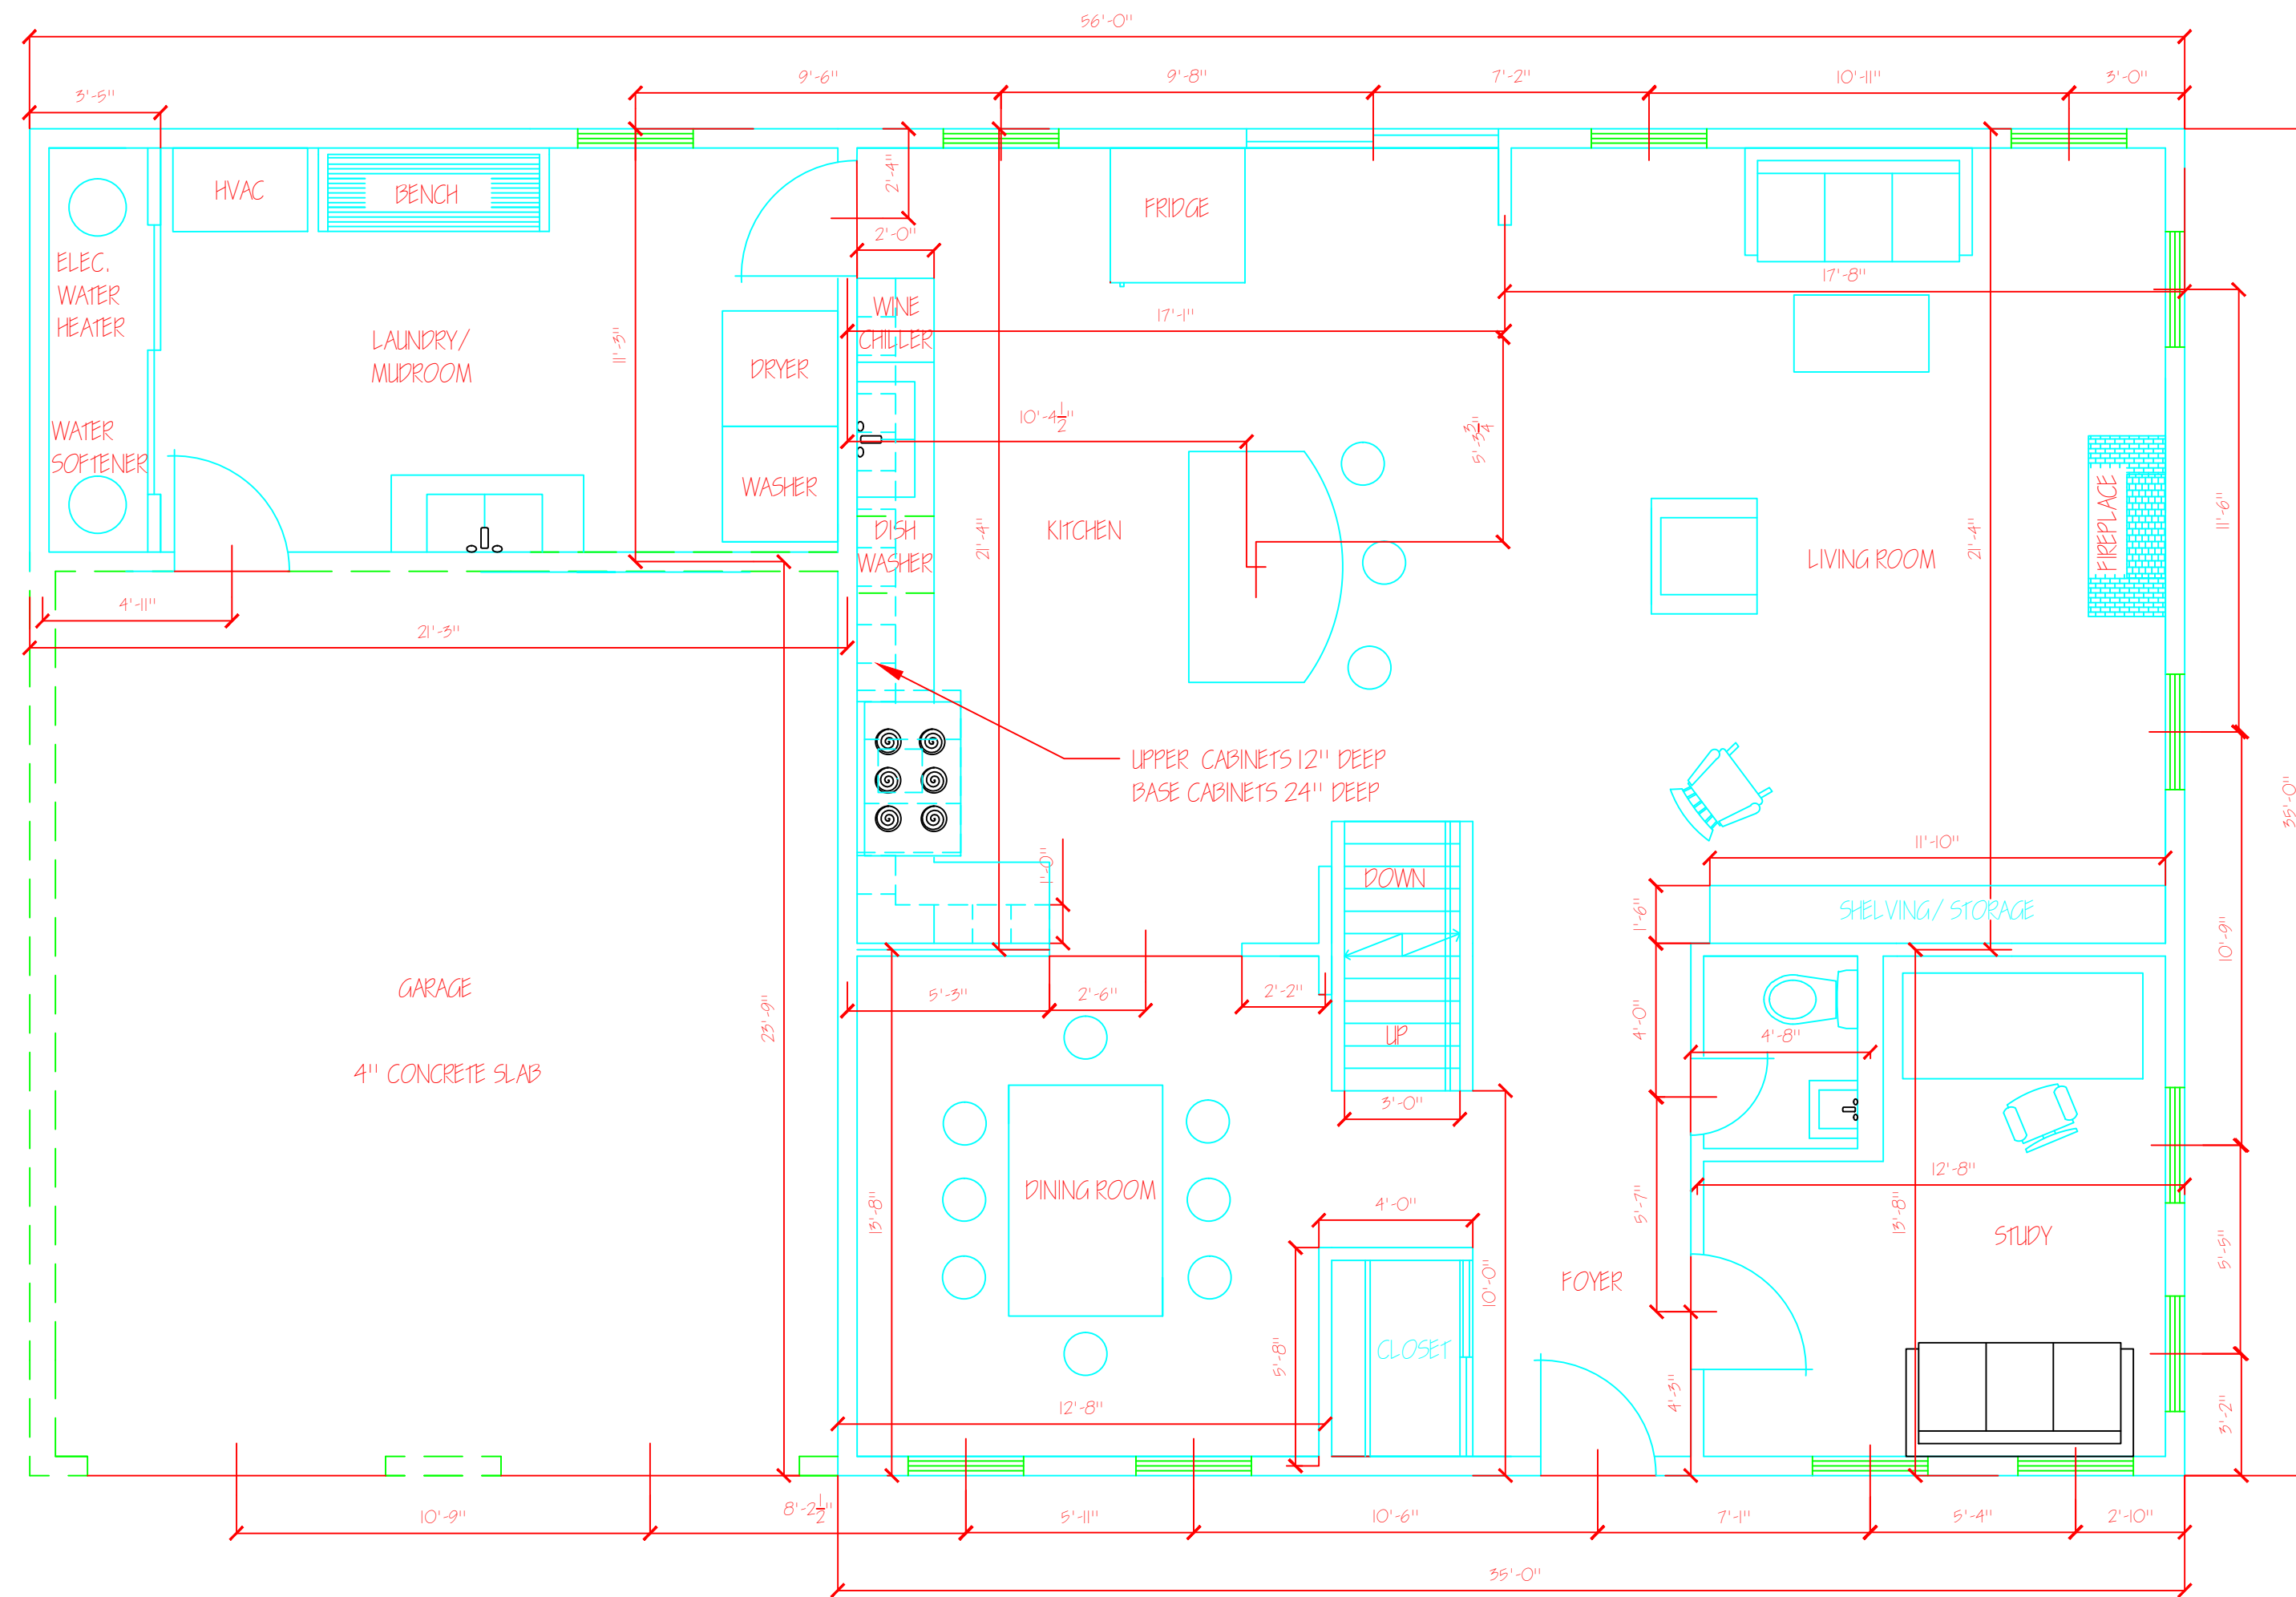

FLOOR PLAN FIRST FLOOR

1/4" = 1'-0"

