


Areas



Space	Gross Area (sq ft)	Net Rentable (sq ft)
Spec Tenant Office	23,188	23,188
Main Electrical Room	991	0
Generaor Room	1,094	0
Atrium	25% of 1,997	0
Core & Circulation	4,868	0
TOTALS	30,640	23,188

76% Efficient

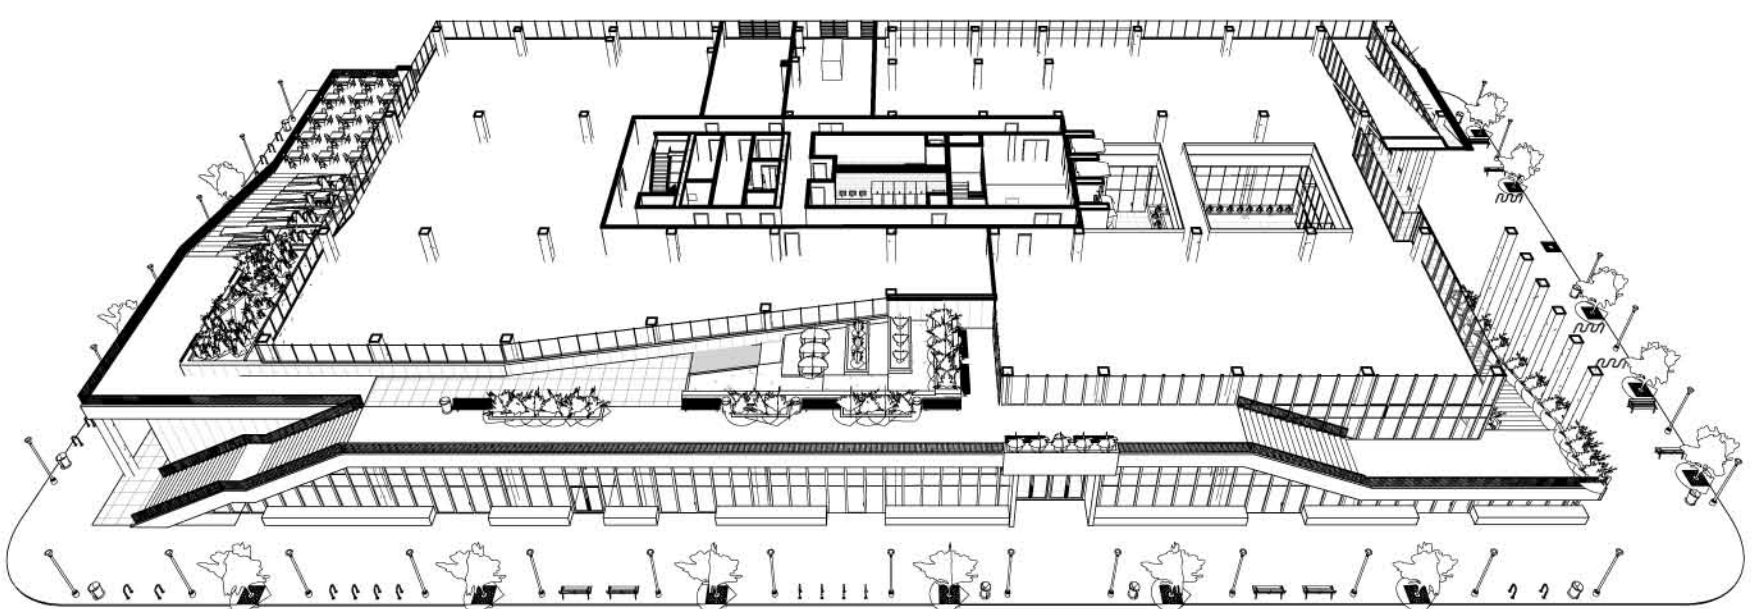

Scale: 1/20"=1'
 0 5 10 20 40

Second Floor Plan

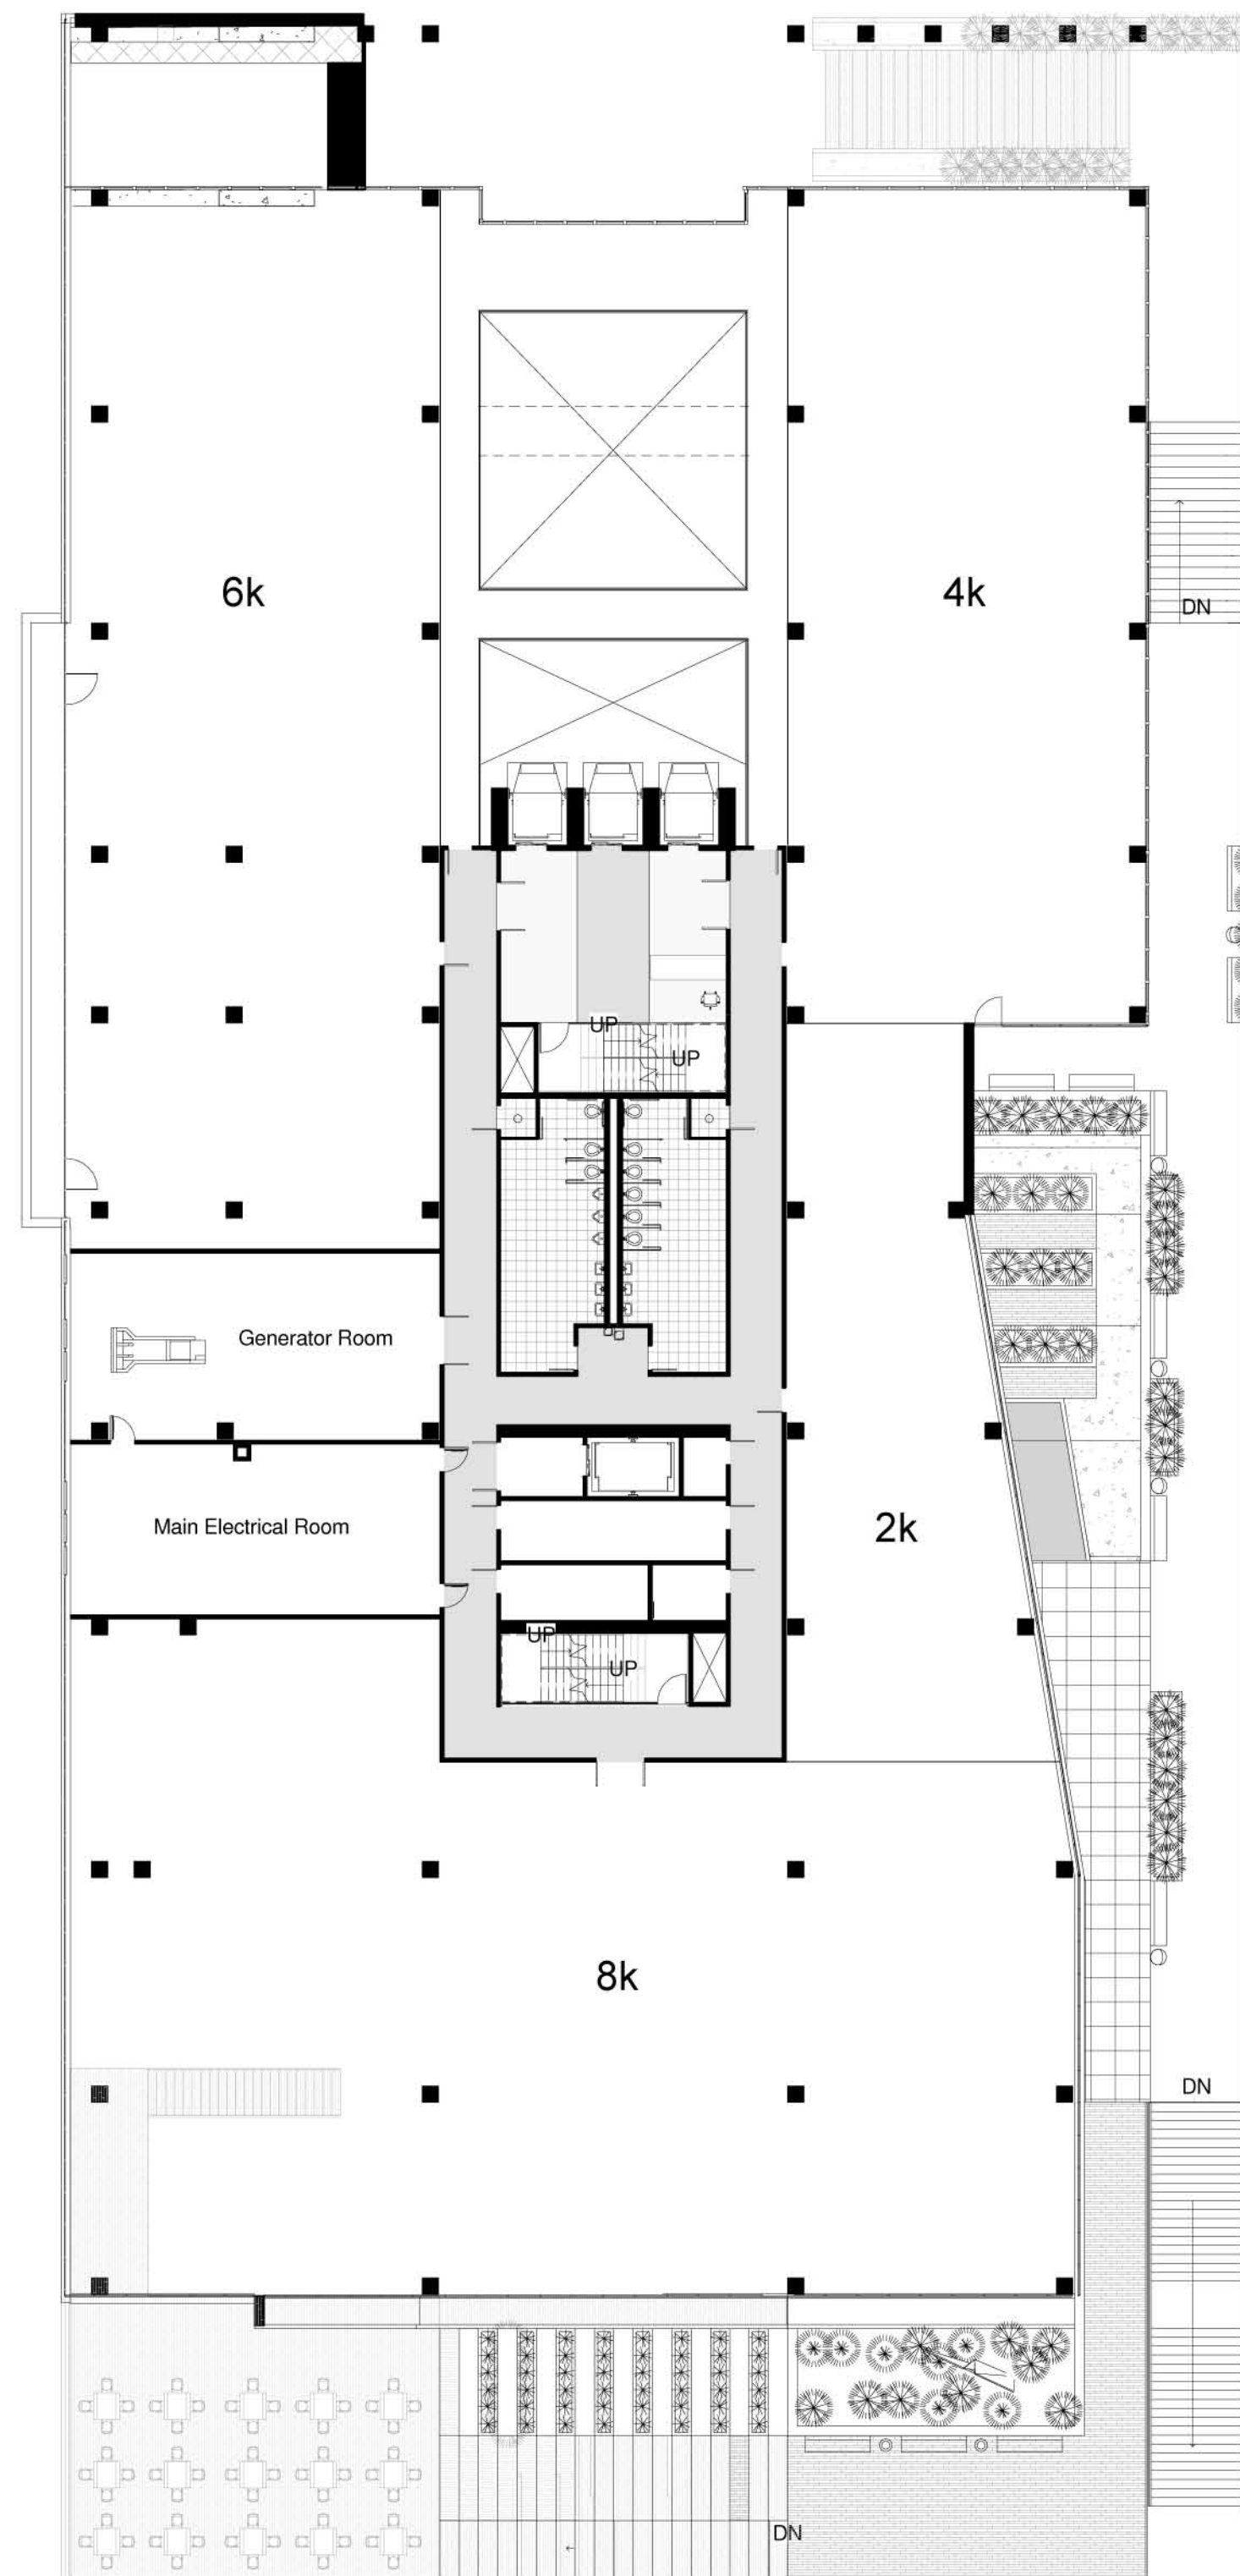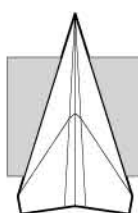

Consultants

- Structural Engineer
Hollie Becker
- Mechanical Engineer
Matthew Setzekorn
- Electrical Engineer
Jim Stadelman
- Aeronautic Specialist
David Aston

Contract Information

Forest City
Washington
1615 L Street NW,
Suite 400
Washington, DC
20036


Phone: 202-406-6600
www.dcwashington.com

Kent State University
College of
Architecture &
Environmental Design

Client



Key Plan

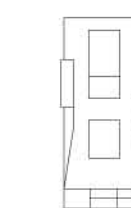

Date: 3/6/2011
 Drwn by: Travis Clarke
 Chkd by: Harker
 Sheet Title:
 Floor Plans