

Consultants

Structural Engineer
Holle Becker
Mechanical Engineer
Matthew Setzekorn
Electrical Engineer
Jim Stadelman
Aeronautic Specialist
David Aston

Contract Information

 
Forest City
Washington
1615 L Street NW,
Suite 400
Washington, DC
20036
Phone: 202-406-6600
www.dcwashington.com

Kent State University
College of
Architecture &
Environmental Design


Client



Key Plan



Date: 4/11/2011
Drwn by: Esposito
Chkd by: Harker
Sheet Title:
One Line Diagram

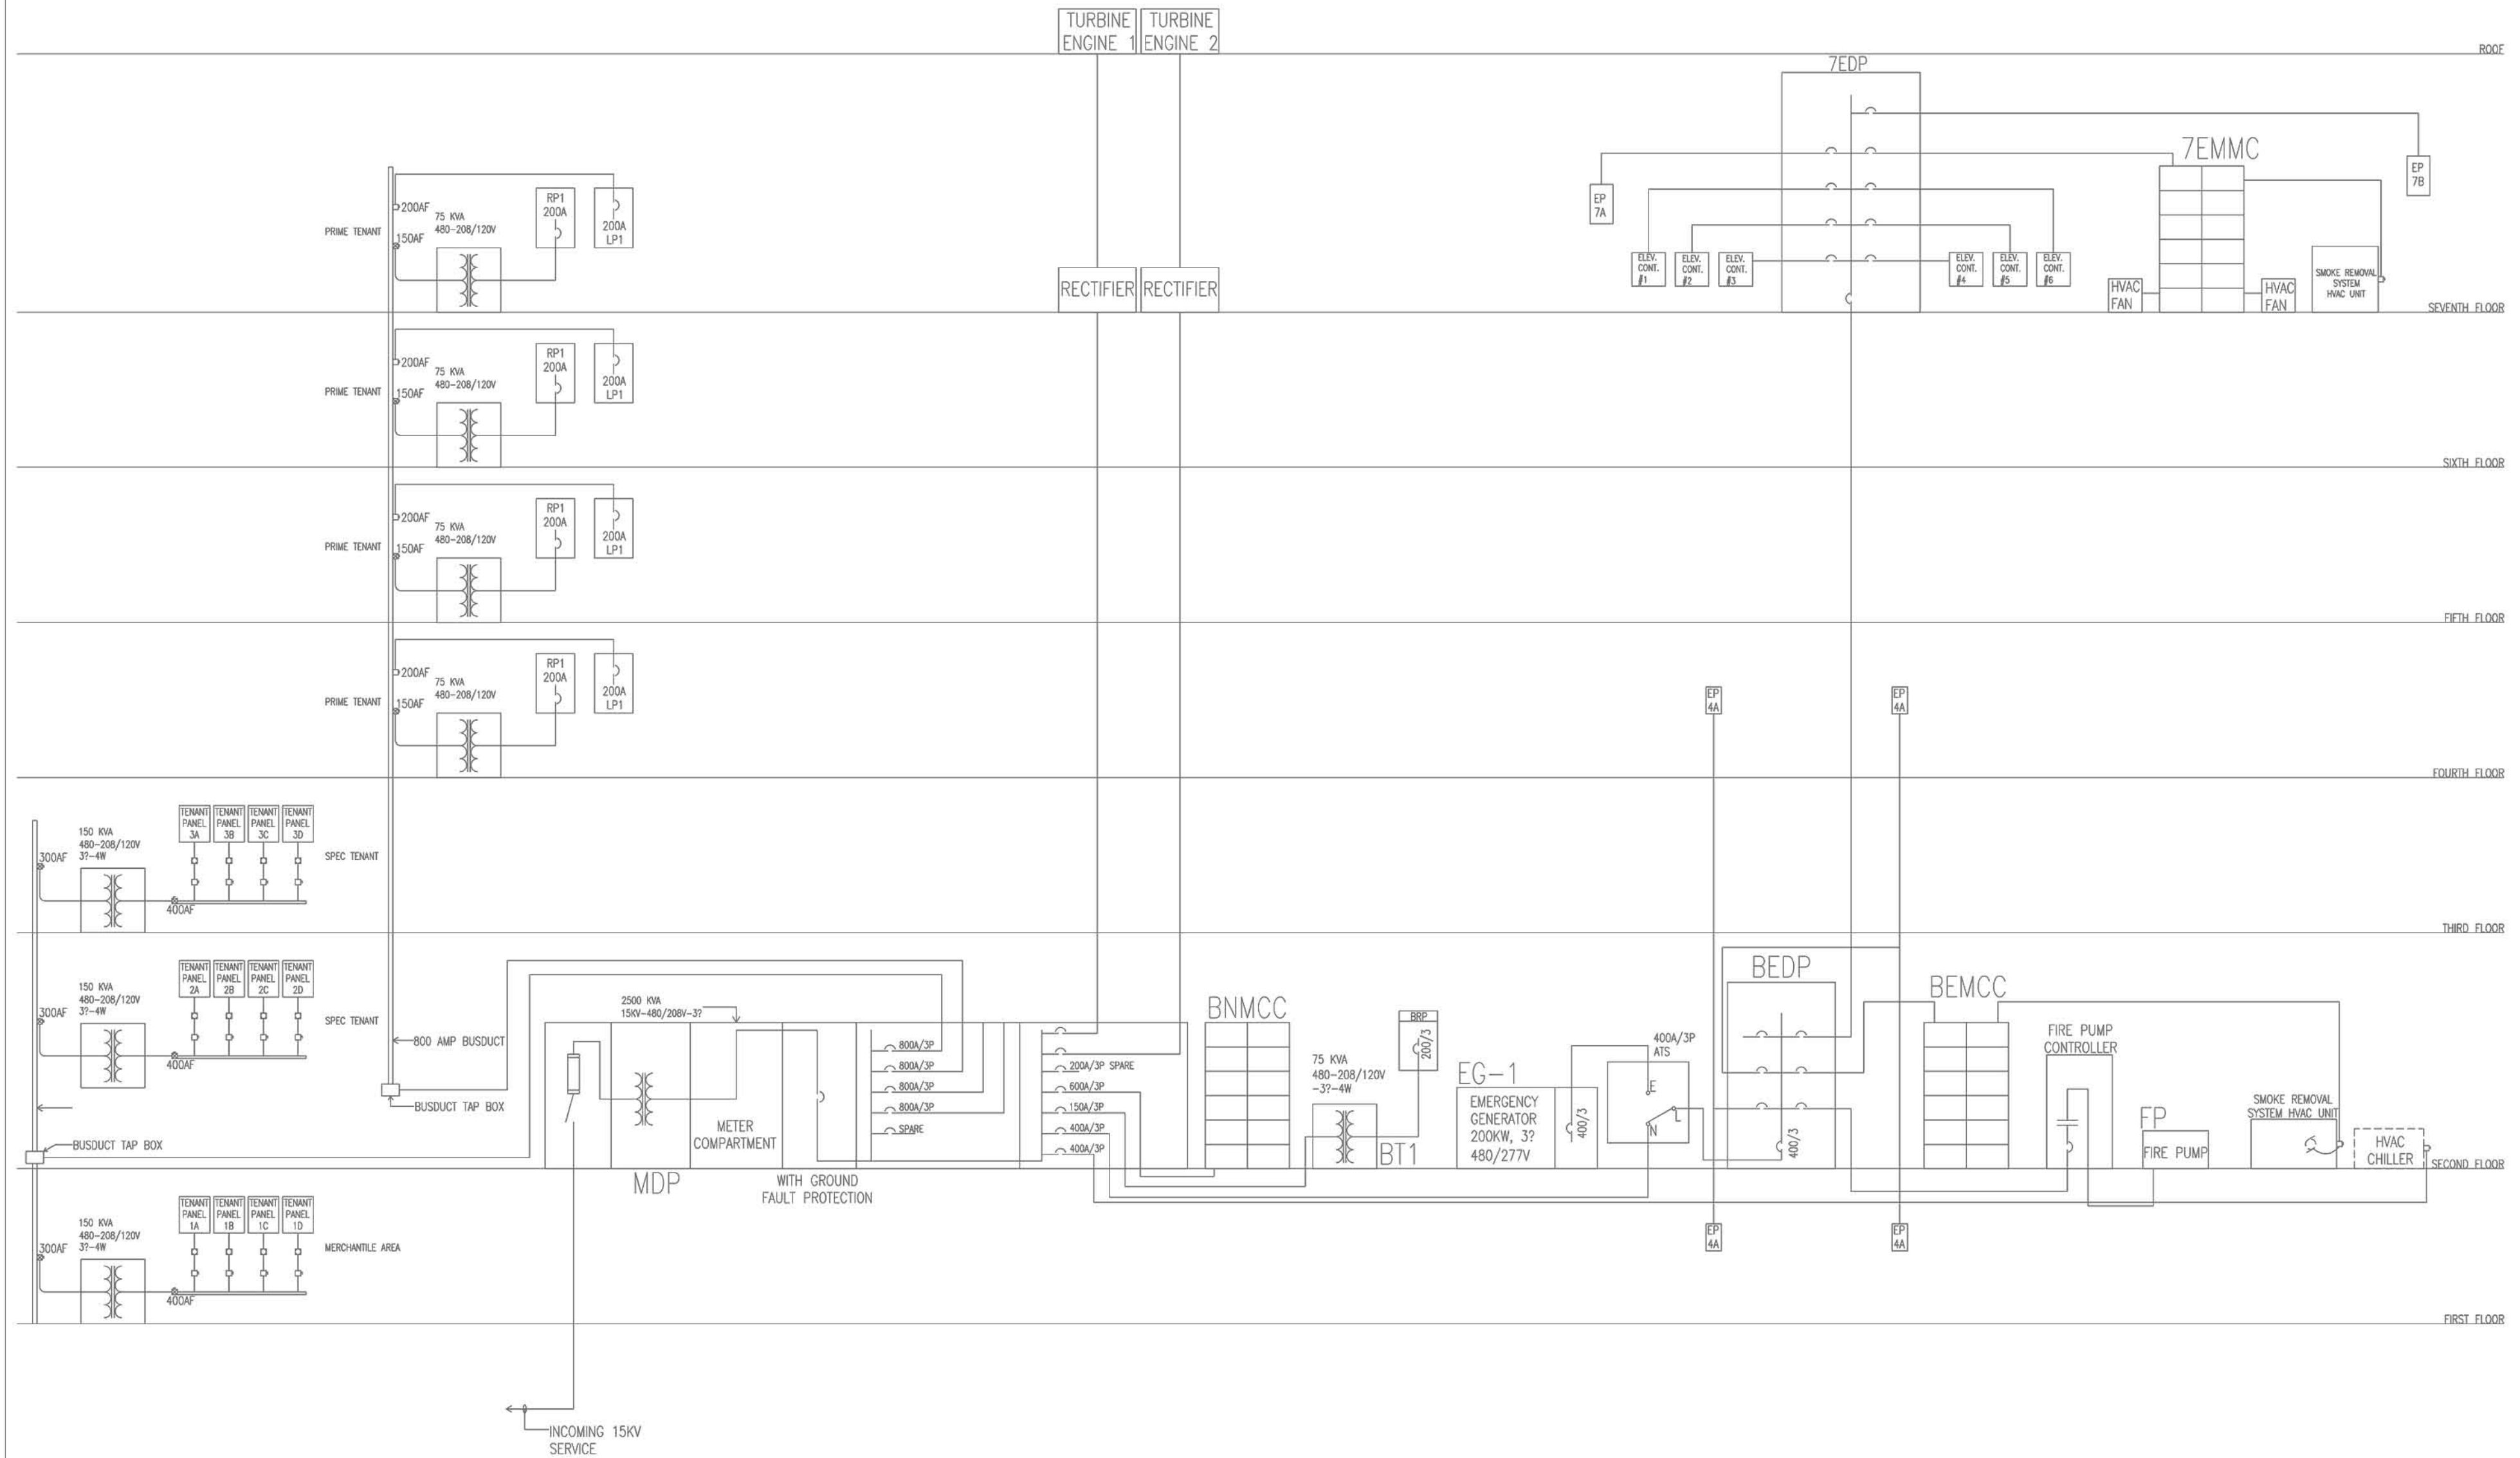

One Line Diagram