



Detail One
Scale: 1" = 1' - 0"

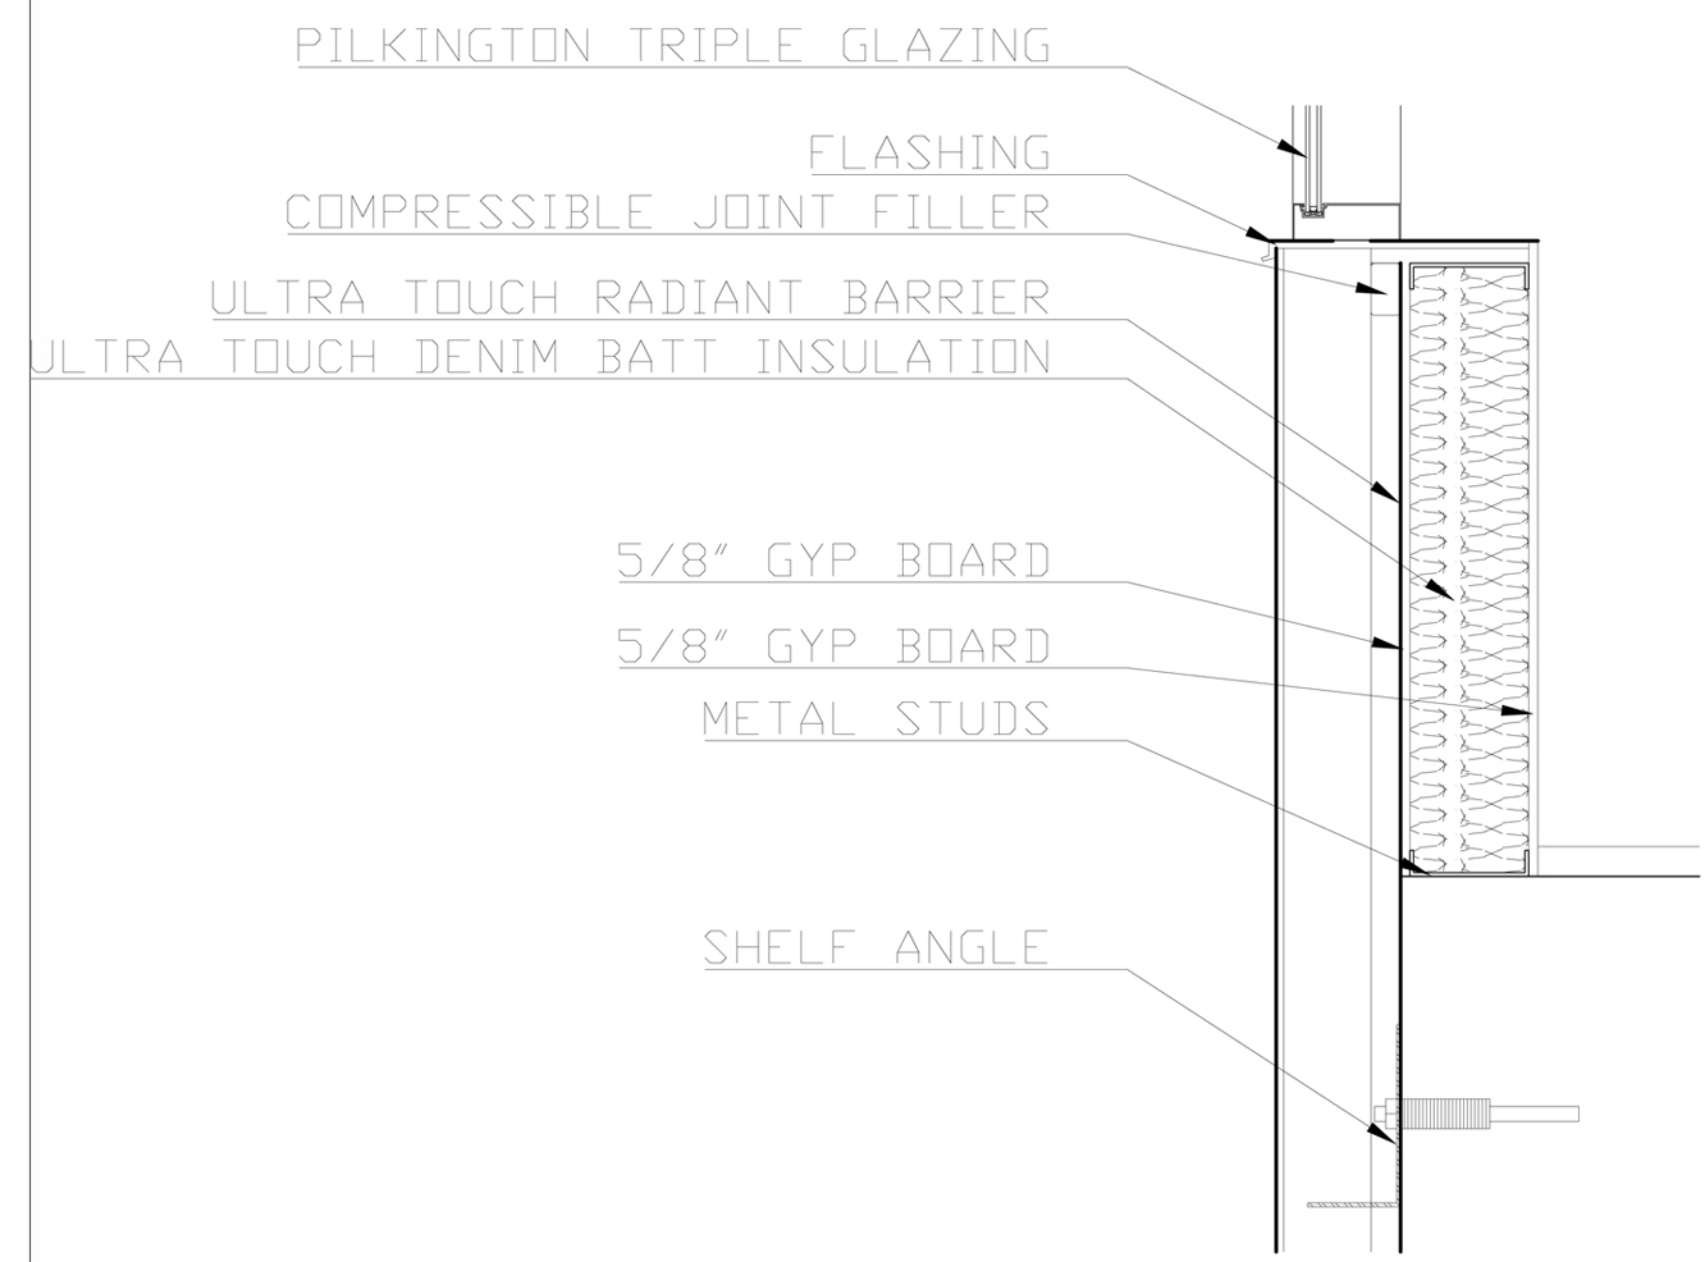

Detail Two
Scale: 1" = 1' - 0"

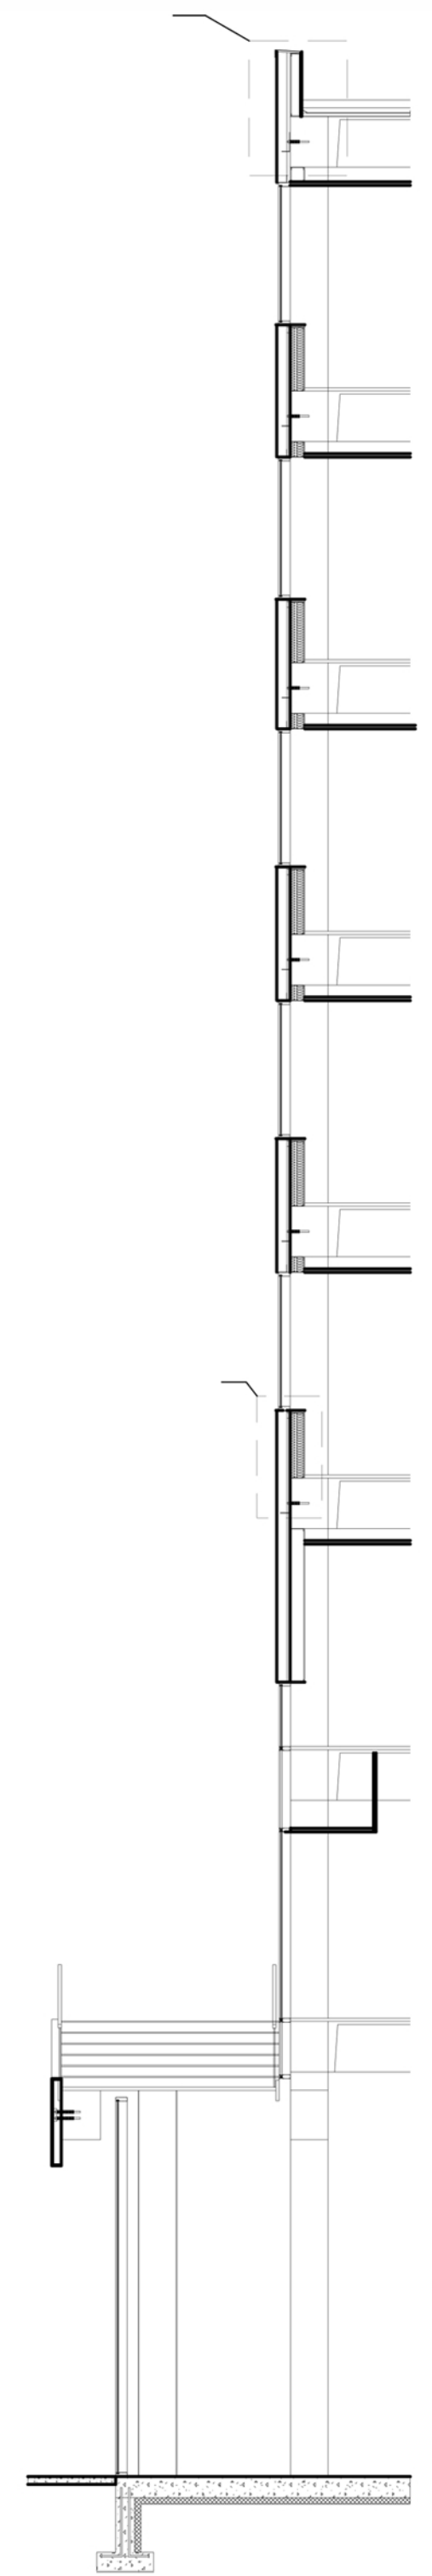

Wall Section B
SCALE: 1"=8"

Consultants

- Structural Engineer
Hollie Becker
- Mechanical Engineer
Matthew Setzekorn
- Electrical Engineer
Jim Stadelman
- Aeronautic Specialist
David Aston

Contract Information

Forest City
Washington
1615 L Street NW,
Suite 400
Washington, DC
20036


Phone: 202-406-6600
www.dcwashington.com

Kent State University
College of
Architecture &
Environmental Design

Client



Key Plan

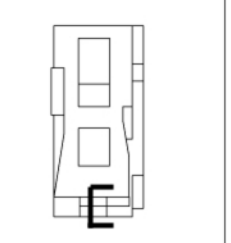

Date: 4/11/2011
Drwn by: Esposito
Chkd by: Harker
Sheet Title:
Wall Section