

Consultants

Structural Engineer  
Holle Becker

Mechanical Engineer  
Matthew Setzekorn

Electrical Engineer  
Jim Stadelman

Aeronautic Specialist  
David Aston

Contract Information

Forest City  
Washington  
1615 L Street NW,  
Suite 400  
Washington, DC  
20036

 
Phone: 202-406-6600  
www.dcwashington.com

Kent State University  
College of  
Architecture &  
Environmental Design

Client





Key Plan




Date: 3/6/2011  
Drwn by: Travis Clarke  
Chkd by: Harker  
Sheet Title:  
Sprinkler Plan

**4K-F-101**

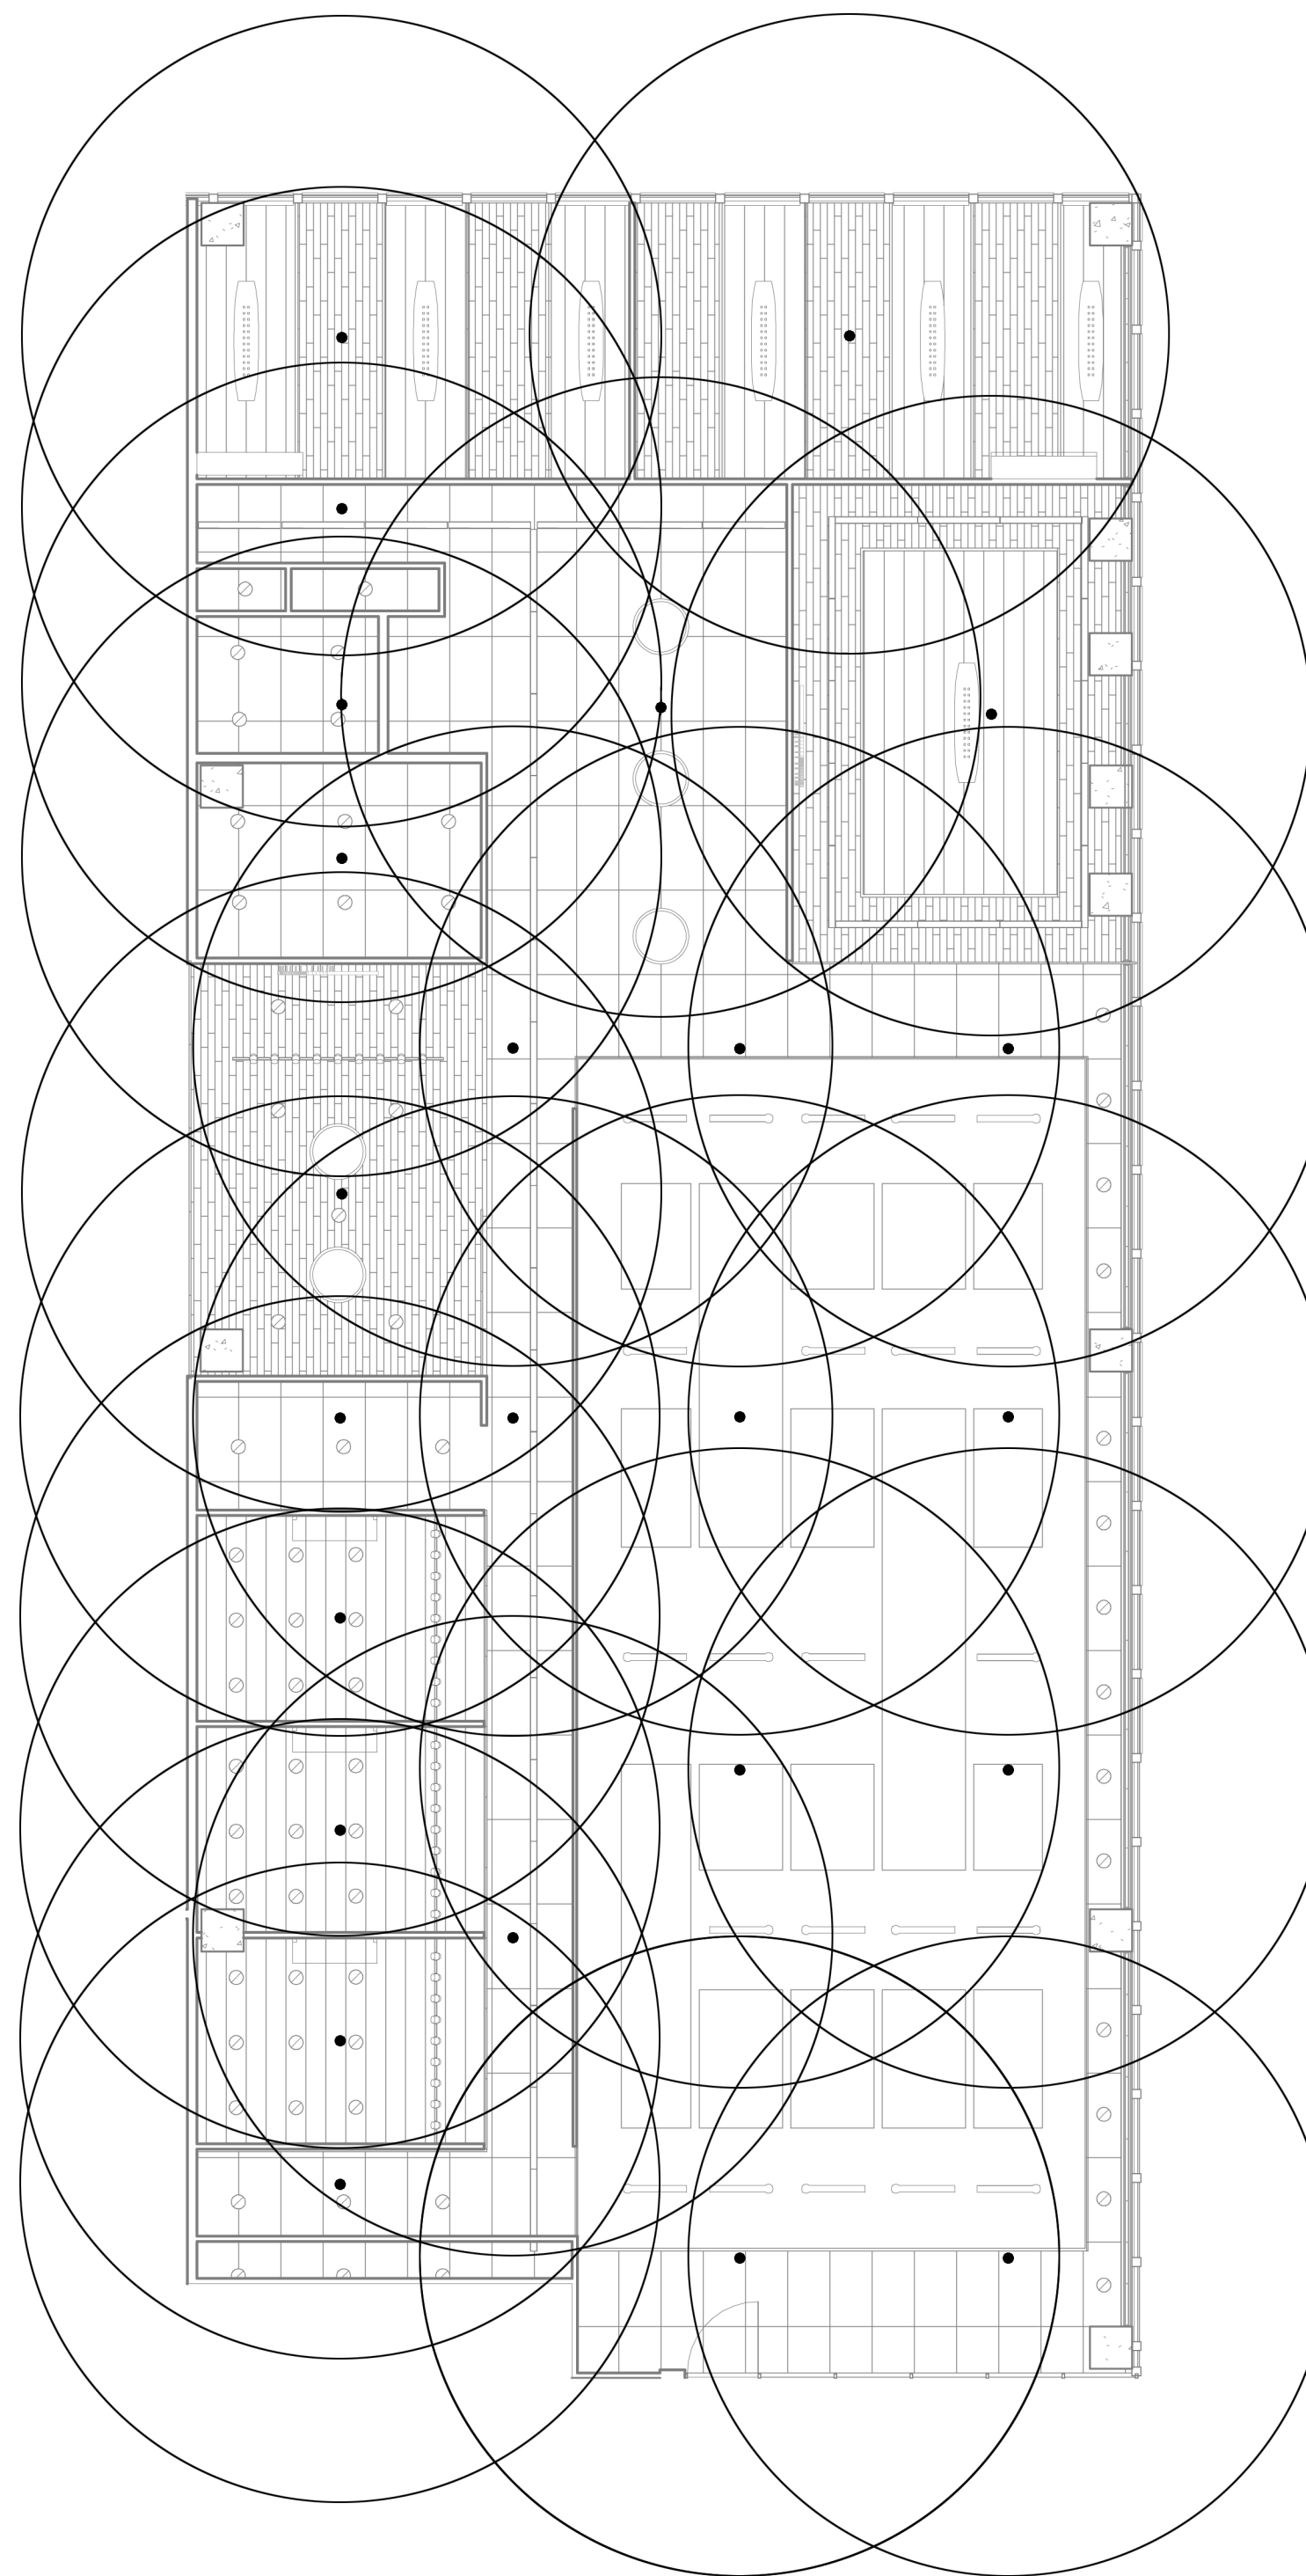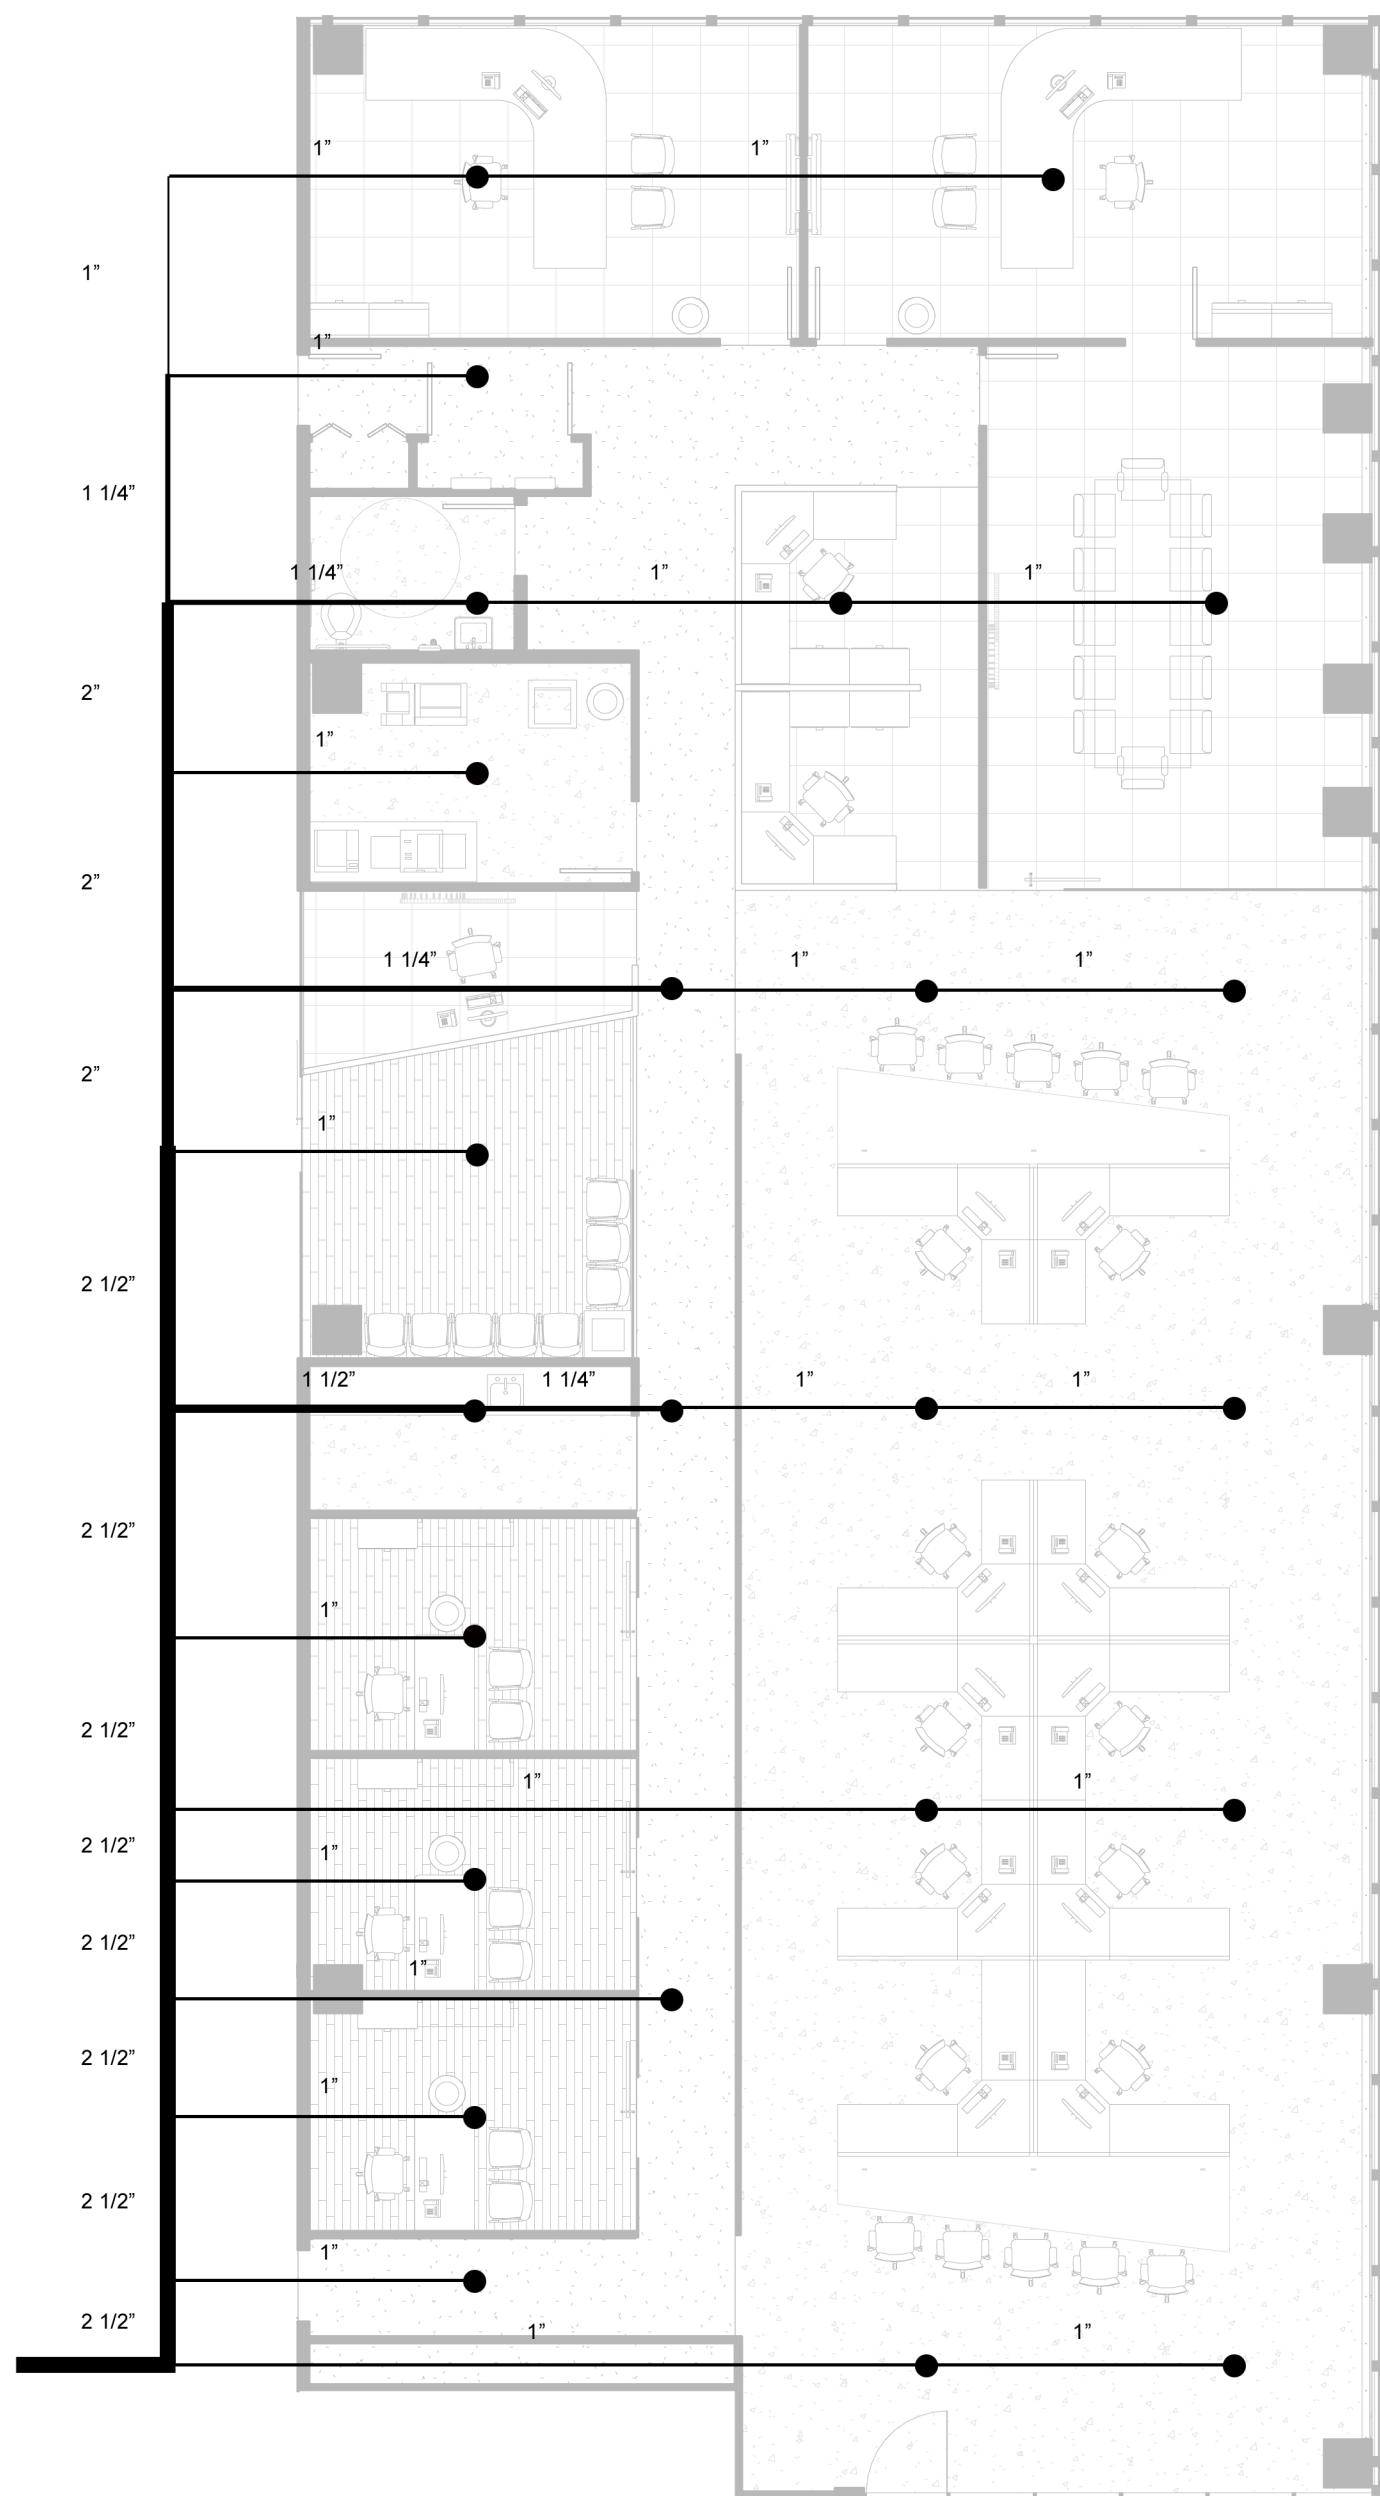

Scale: 1/8"=1'  
0 1 2 4 8 16

**4k Sprinkler Plan**  
Pipe Layout and Sizing

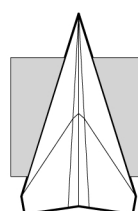

Scale: 1/8"=1'  
0 1 2 4 8 16

**4k Sprinkler Plan**  
Sprinkler Radius & Protected Area

