


120V Lighting Plan [Panel A]

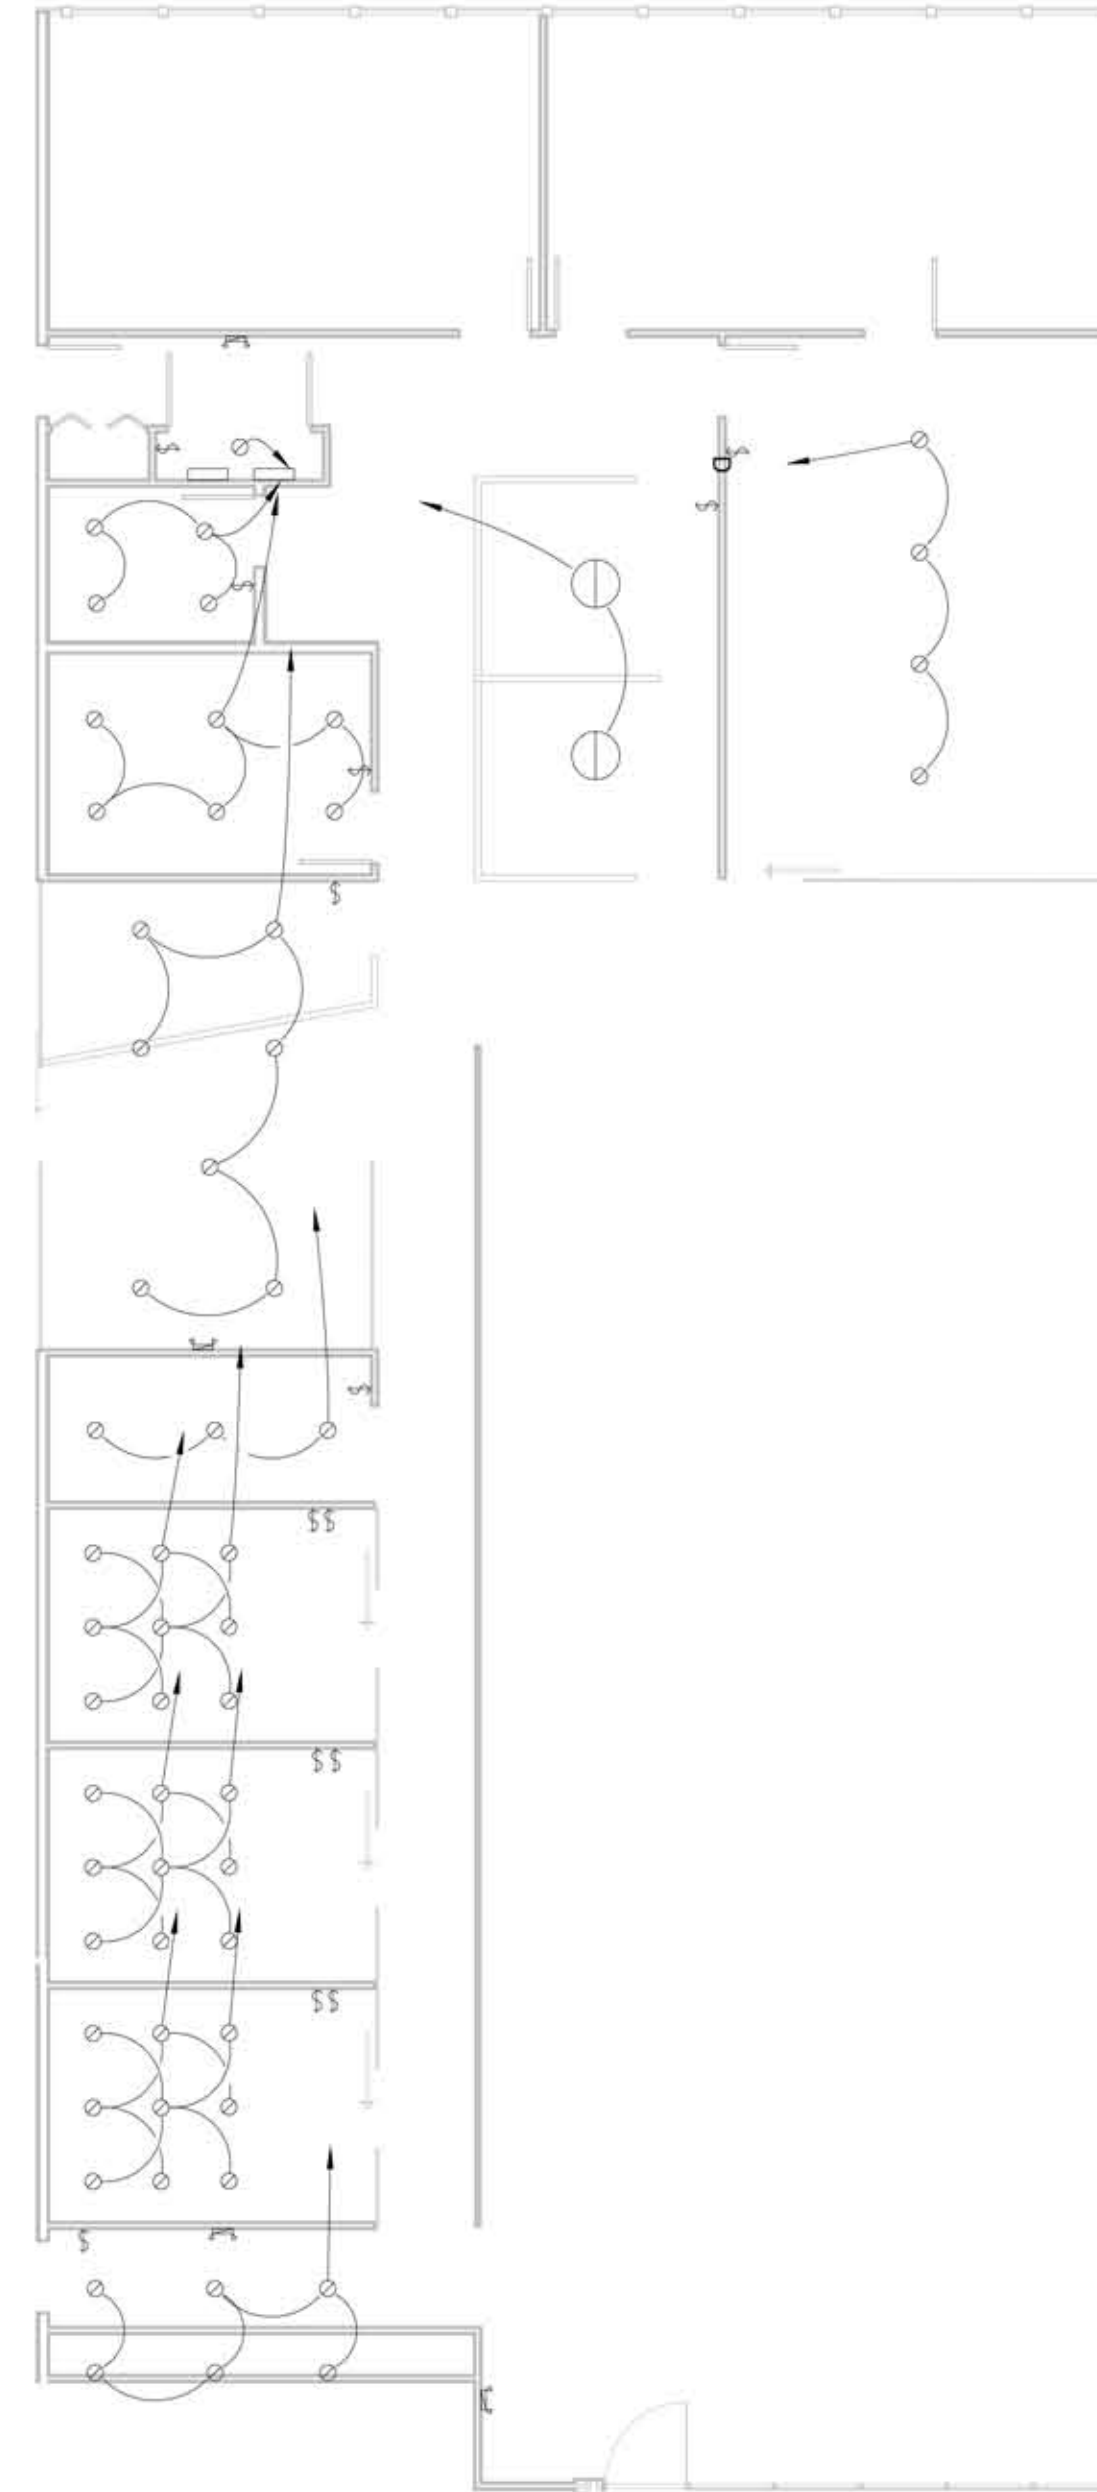

277V Lighting Plan [Panel B]

Scale: 1/8"=1'  
 0 1 2 4 8 16

# Lighting Plan



**Consultants**

Structural Engineer  
 Hollee Becker  
 Mechanical Engineer  
 Matthew Setzekorn  
 Electrical Engineer  
 Jim Stadelman  
 Aeronautic Specialist  
 David Aston

**Contract Information**


Forest City  
 Washington  
 1615 L Street NW,  
 Suite 400  
 Washington, DC  
 20036  
 Phone: 202-406-6600  
 www.dcwashington.com

Kent State University  
 College of  
 Architecture &  
 Environmental Design

**Client**



**Key Plan**

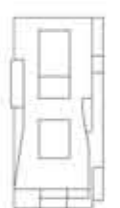

Date: 4/11/2011  
 Drwn by: Esposito  
 Chkd by: Harker  
 Sheet Title:  
 Lighting Plan