



**Tracy Potter
 Architecture + Design**
 101 Huntington Ave
 Boston, MA 02199
 tjp56@cornell.edu
 508 . 965 . 9111

Project Name

**PIKE PLACE: CENTER
 FOR THE ARTS**

300 SOUTH SALINA ST.
 SYRACUSE, NY 13202

Issue Date

12/11/2012

Notes

1. All sprinkler heads placed at 10' on center unless otherwise noted
2. refer to light fixture cut sheets for further information
3. Mount security cameras 10' AFF


Keyed Notes

- [A] All Back of house areas are to be textured Armstrong Acoustic Ceiling tiles #942 in white
- [B] Theater microphones to be mounted to ceiling grid 10' AFF
- [C] typical ceiling treatment to be suspended drywall ceiling except where otherwise noted
- [D] Mount theater lighting grid 12' AFF

Legend

- [PT 01] Sherwin Williams Latte (eggshell) #6108
- [PT 02] Sherwin Williams White (flat) #A61W00153
- [PT 03] Sherwin Williams Black of Night (eggshell) #6993
- ⬆ Ceiling height notation
- ⊕ North indication
- [XXX] Room number and title
- (X) - - Structural Lines

Key Plan: Pike Place

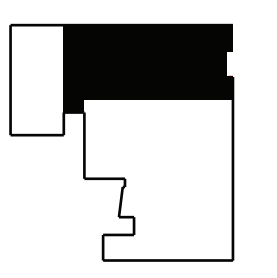

Scale


3/16" = 1'-0"

Drawing Title

First Floor Reflected Ceiling Plan

Drawing Number

A-2

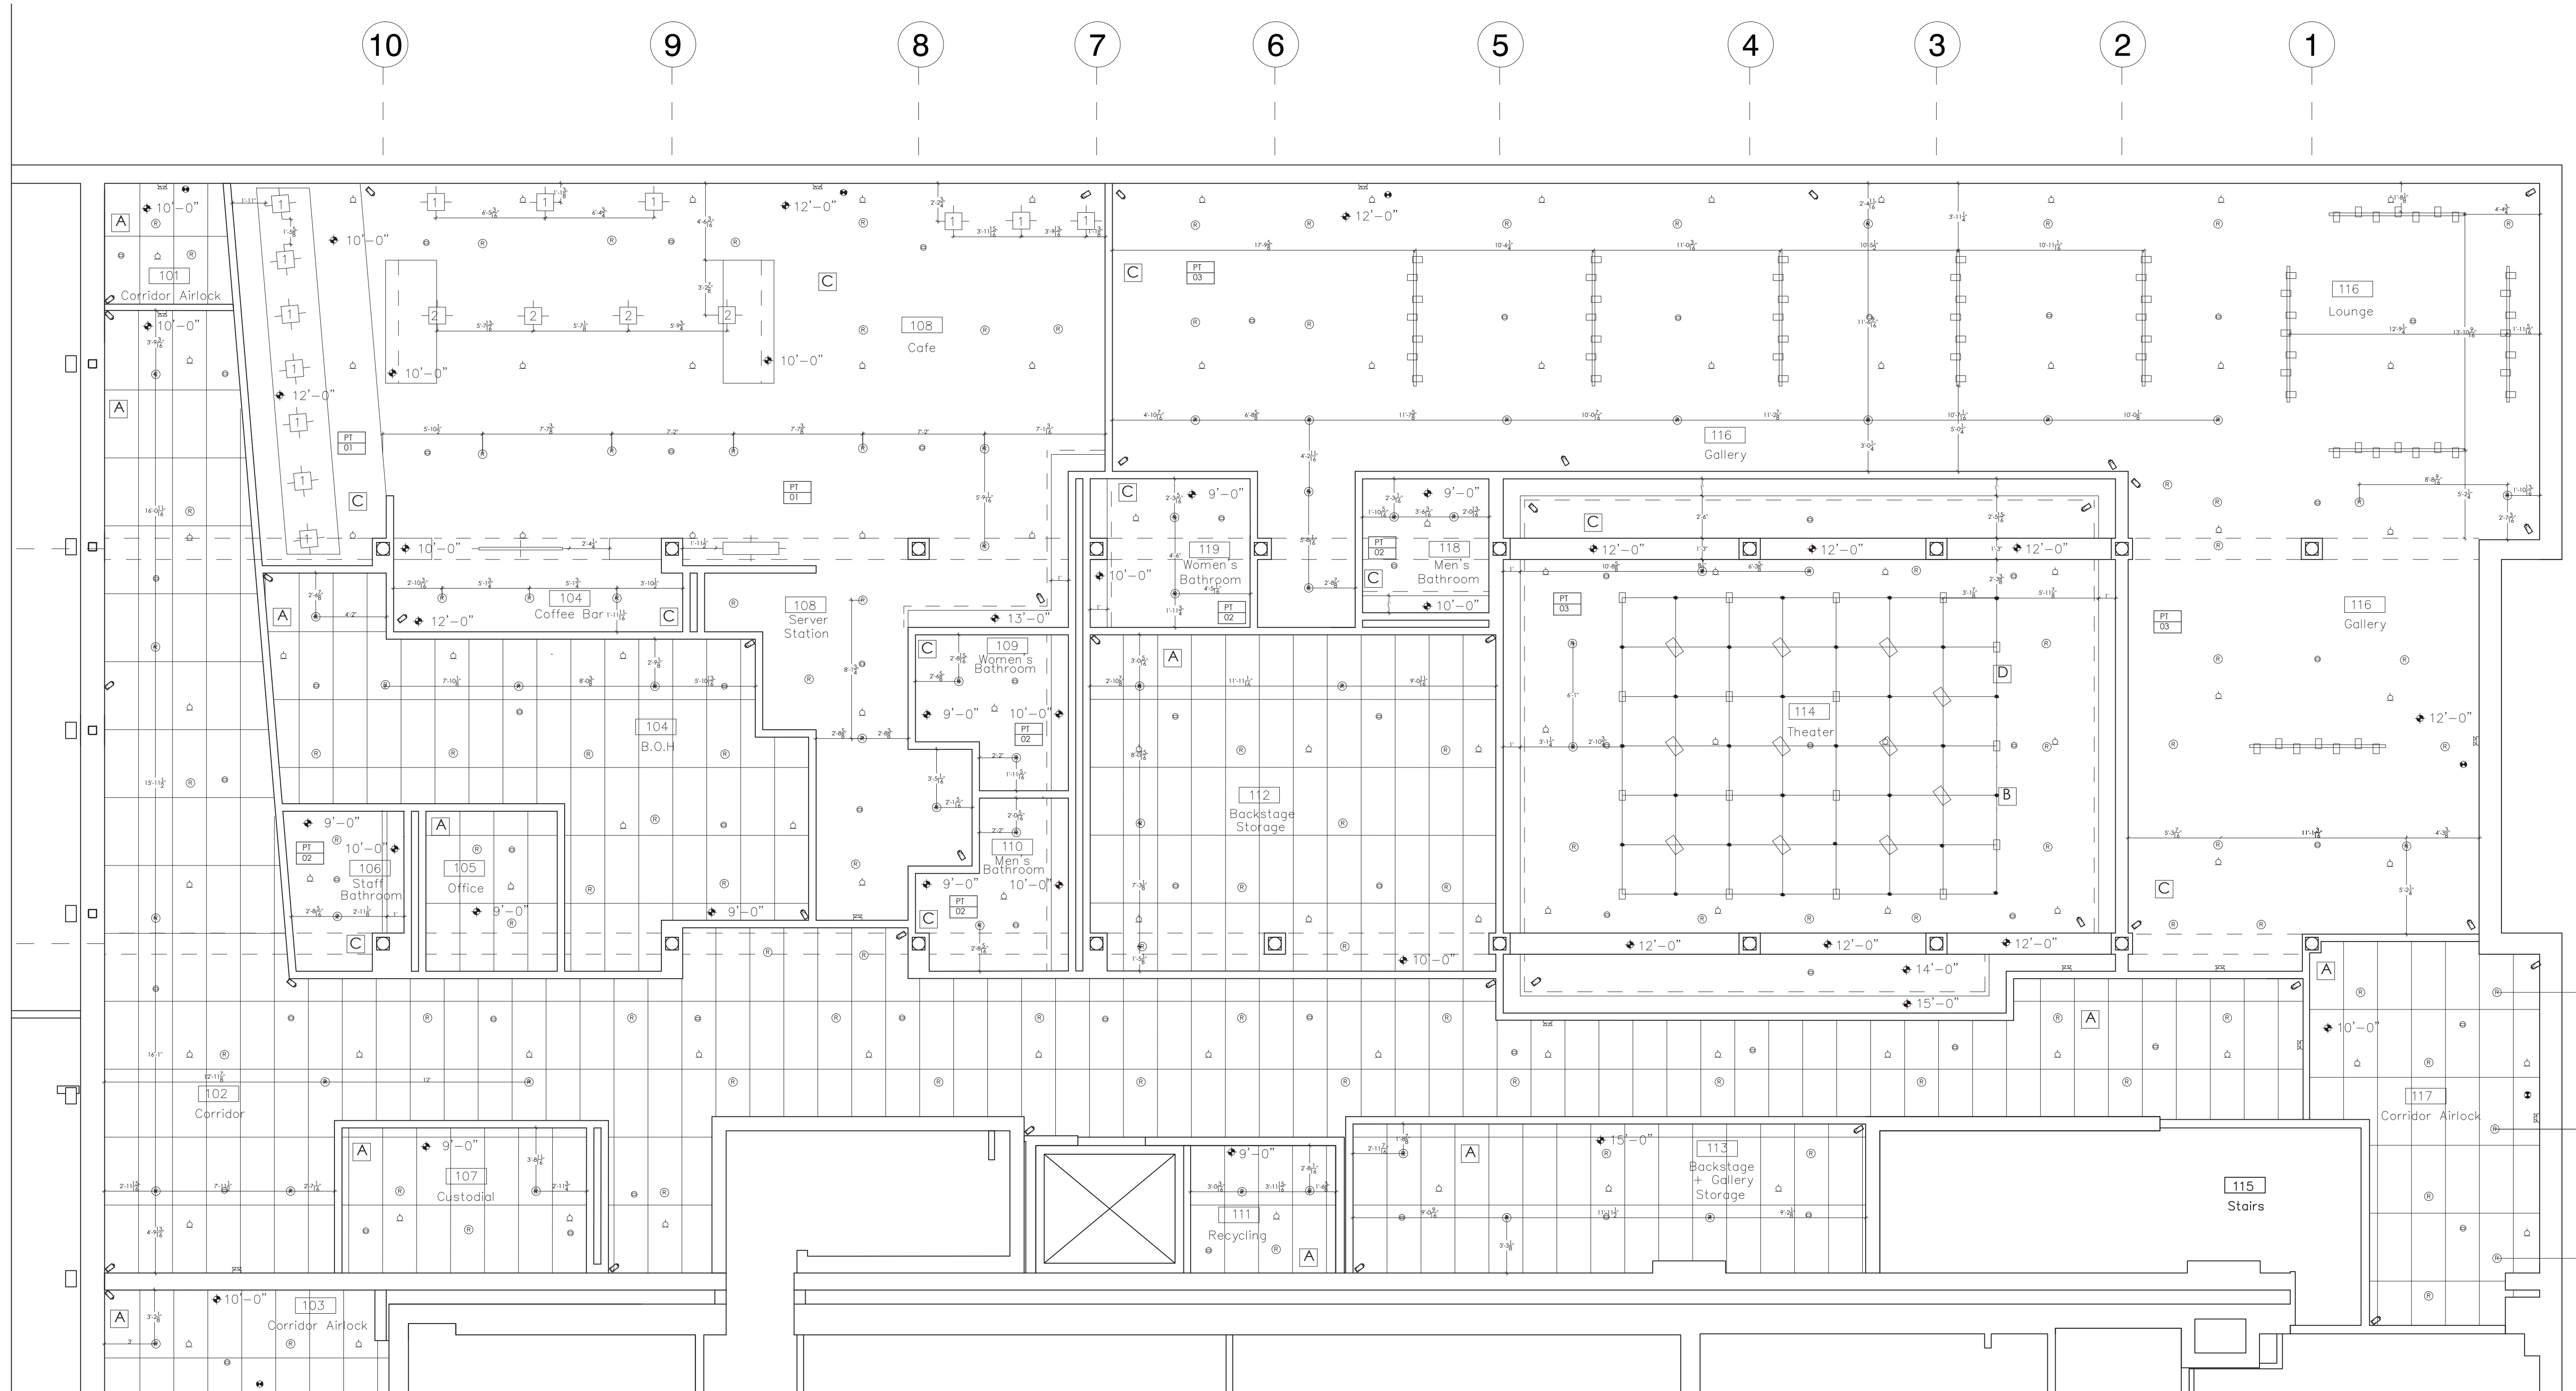

Symbol	Description	Name	Manufacturer	Product/ Model #	Wattage
[C]	Camera N.I.C	Vadilio Color Video Camera	Sony	EVJHD1	-----
[E]	Emergency Lighting	Exit Emergency Lighting sign	Lighting Components of NY	TCP 20784	4
[S]	Smoke Deflector	Dual Sensor DC Pwr Smoke Alarm	First Alert	SA320CN	-----
[M]	Microphone	Cardioid Condenser Hanging Microphone	Audio Technica	UB53R	-----
[E]	Exit Sign	Lumapro	Grainger	6CGL5	2.5
[S]	Sprinkler	Pendant Sprinkler Head	Brooks	BRO34 SP	-----
[T]	Track Lighting	Line Voltage Track Lighting	WAC	HTK-704	1000
[P]	Pendant Light	Small Clavius Square Pendant	AXO Light	SPCLAVIP	60
[P]	Pendant Light	Square Boon Light	by Moooi	MOI-SquareBoon	60
[P]	Pendant Light	long & hard suspension lamp	Flos	FU338050	20
[P]	Pendant Light	Clavius Linear Suspension	AXO Light	SPCLAVIUFLE	39
[R]	Recessed Can Light	LED 411 Downlight	WAC	HR-LED411	111/18
[C]	Cove Lighting	Concealed White LED	Philips Lightolier	CWL400612	4
[T]	Theater Lighting	Quartz Focusing Fresnels	Altman	165Q	750

1 First Floor Reflected Ceiling Plan
 Scale: 3/16" = 1'-0"

