


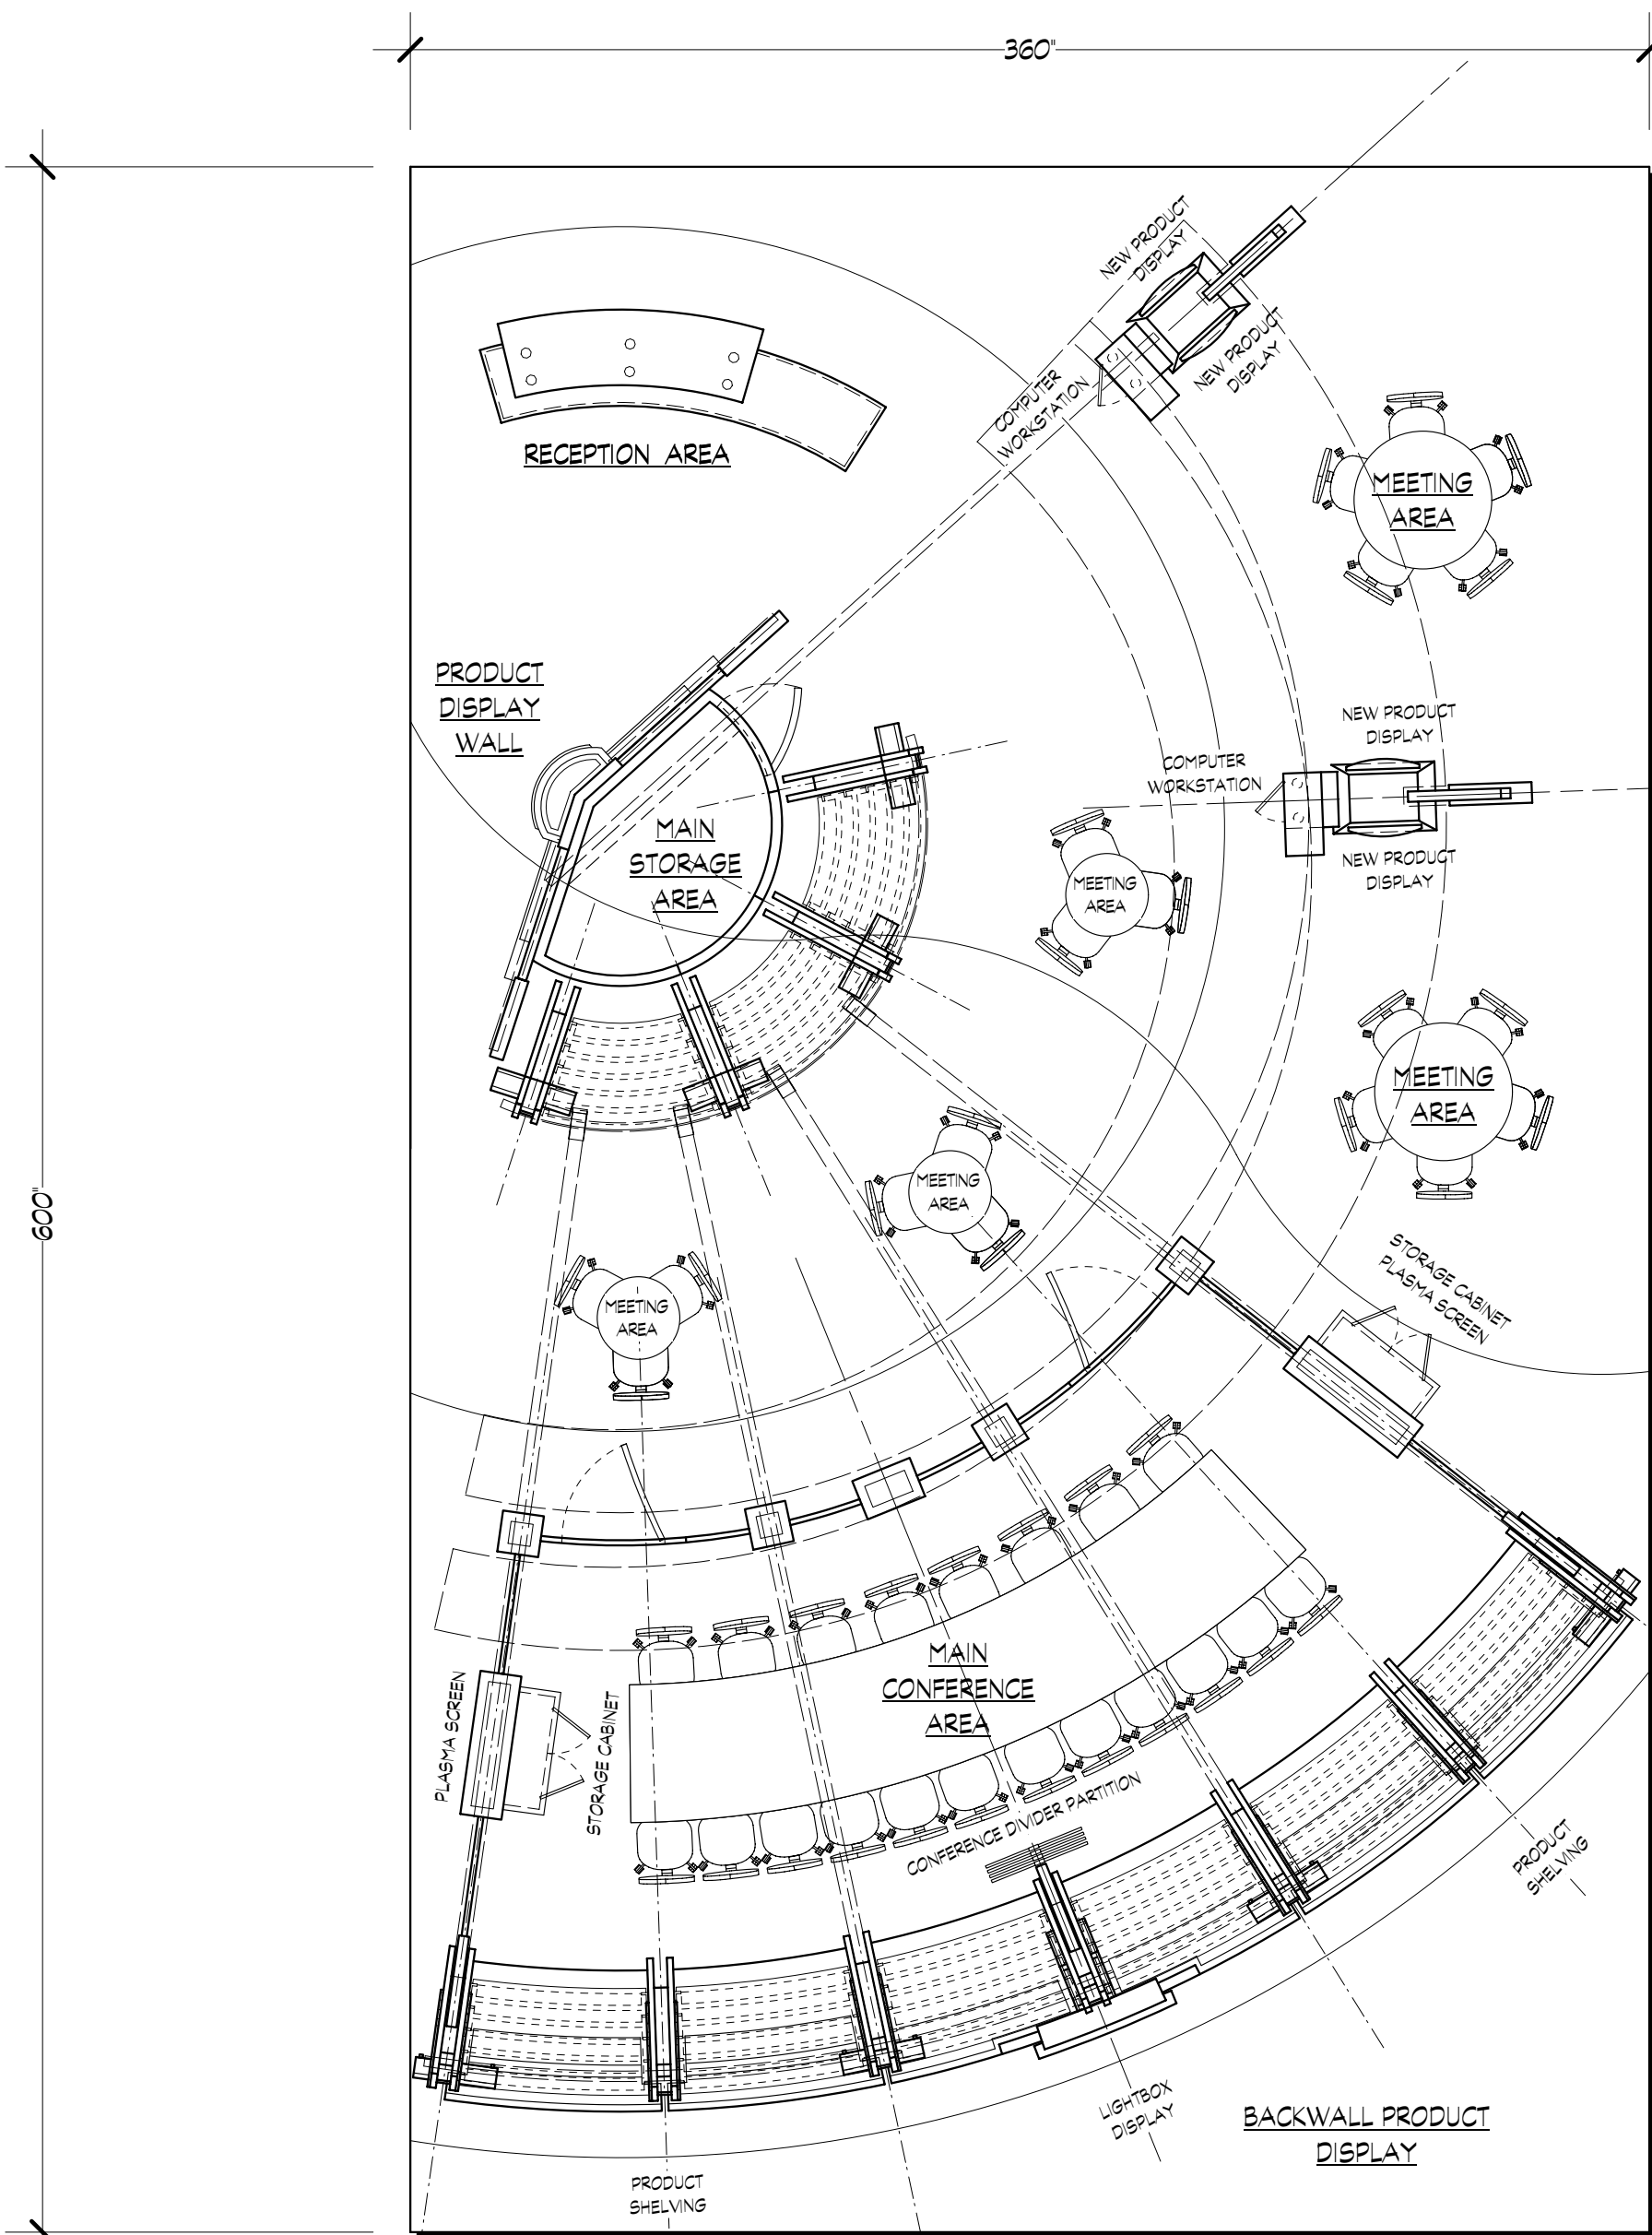

30' X 50' MAIN FLOOR PLAN

Scale: 1:72

A2

VENDOR CONTACT INFORMATION:

MANUFACTURER: TRANSLITE-SANOMA 22678 BROADWAY, STE. A1 SONOMA, CA 95476 707.996.6906	MANUFACTURER: TECH LIGHTING 1718 WEST FULLERTON CHICAGO, IL 60614 773.883.6110	DISTRIBUTOR: PROSOURCE 701 DEL NORTE, STE 225 OXNARD, CA 93030 805.983.1314
DISTRIBUTOR: WHITE ASSOCIATES 2344 HYPERION AVE LOS ANGELES, CA 90027 800.850.0855	DISTRIBUTOR: LIGHTING ARTISTRY 18005 SKYPARK, STE. F IRVINE, CA 92614 949.253.6950	MANUFACTURER: TABLE BASES.COM PO BOX 215 BOULDER CREEK, CA 95006 (877) 930-2737
MANUFACTURER: EXPOTRANS 26845 VISTA TERRACE LAKE FOREST, CA 92630 949.261.5483	MANUFACTURER: MCMASTER-CARR P.O. BOX 54960 LOS ANGELES, CA 90054 562.692.5911	MANUFACTURER: MOSS INC. 248 NORTHPORT AVE. BELFAST, MN 04915 800.341.1557

MASTER PURCHASING SCHEDULE

MANUFACTURER	DISTRIBUTOR	ORDER NUMBER	DESCRIPTION	QTY.
TRANSLITE	WHITE ASSOCIATES	JK-170C-1-S-BK-BK	CURVED PHANTAJACK LOW VOLTAGE ARMLIGHTS FROM TRANSLITE-SANOMA	18
TRANSLITE	WHITE ASSOCIATES	JK-170V-1-S-BK-BK	CURVED PHANTAJACK LOW VOLTAGE ARMLIGHTS FROM TRANSLITE-SANOMA	6
TRANSLITE	WHITE ASSOCIATES	910	10' LOW VOLTAGE EXTENSION CORD	4
TRANSLITE	WHITE ASSOCIATES	920	20' LOW VOLTAGE EXTENSION CORD	4
TECH LIGHTING	LIGHTING ARTISTRY	700-AT600P	600w (DUAL 300w) LOW VOLTAGE POWER SUPPLY FROM TECH LIGHTING	2
TECH LIGHTING	LIGHTING ARTISTRY	700-MOAE3S	MO-AERO FIXTURE (NICKLE) SPECIFY ROUND GLASS SHIELD (AMBER)	5
TECH LIGHTING	LIGHTING ARTISTRY	700-MOTRPN5	MO-TOPEDO PENDANT FIXTURE (NICKLE) SPECIFY ROUND GLASS SHIELD (AMBER)	10
TECH LIGHTING	LIGHTING ARTISTRY	700-MOPRCO2S	MOP-REC-S POWER FEED CANOPY	2
TECH LIGHTING	LIGHTING ARTISTRY	700-MOP12S	12 SATIN NICKLE POWER EXTENDER TO BE CUT IN FIELD TO CUSTOM LENGTH	2
TECH LIGHTING	LIGHTING ARTISTRY	700-MOS12S	12' SATIN NICKLE RIGID STANDOFF TO BE CUT IN FIELD TO CUSTOM LENGTH	4
TECH LIGHTING	LIGHTING ARTISTRY	700-MOPVLT5	MOP-VAULT FLEXIBLE POWER CONNECTOR	2
TECH LIGHTING	LIGHTING ARTISTRY	700-MOCVLT5	MOP-VAULT FLEXIBLE CONNECTOR	4
TECH LIGHTING	LIGHTING ARTISTRY	700-MOA96AMS	COLORLED 96" MONORAIL CUSTOM CUT TO 53 1/2' AND BEND TO 198" R	4
TECH LIGHTING	LIGHTING ARTISTRY	700-MOA48AMS	COLORLED 48" MONORAIL SPECIFY BEND TO 361" R	4
TECH LIGHTING	LIGHTING ARTISTRY	700-MOA24AMS	COLORLED 24" MONORAIL CUSTOM CUT TO 18' AND BEND TO 361" R	2
TECH LIGHTING	LIGHTING ARTISTRY	700-WMOSO1S	SATIN NICKLE STANDOFFS	18
TECH LIGHTING	LIGHTING ARTISTRY	700-MOPENDS	SATIN NICKLE END POWER FEEDS	6
TECH LIGHTING	LIGHTING ARTISTRY	NONE	LOW VOLTAGE POWER CABLE	30FT
TECH LIGHTING	LIGHTING ARTISTRY	700-MOCINC	INSULATED CONNECTOR	1
TECH LIGHTING	LIGHTING ARTISTRY	700-MOCCNS	CONDUCTIVE CONNECTOR	2
TECH LIGHTING	LIGHTING ARTISTRY	700-MOCCAPS	ENDCAPS	2
MOSS	MOSS	N/A	1 1/2" LOW PROFILE CLIPS	36
MOSS	MOSS	N/A	1 1/2" LIGHT STYLE CLIPS	14
MOSS	MOSS	N/A	CIRCULAR FLAT TENSION FABRIC CANOPIES AS PER SHEET M2	2
MOSS	MOSS	N/A	CURVED UPRIGHT TENSION FABRIC PANELS AS PER SHEET M1	9
TABLE BASES.COM	TABLE BASES.COM	AF26TOL	FOLDING CONFERENCE TABLE BASES	2
TABLE BASES.COM	TABLE BASES.COM	B30	X-STYLE TABLE BASES FOR ROUND TABLES SPECIFY REGULAR HEIGHT	2
TABLE BASES.COM	TABLE BASES.COM	B22	X-STYLE TABLE BASES FOR ROUND TABLES SPECIFY BAR HEIGHT	3
MCMASTER-CARR	MCMASTER-CARR	1269A12	BIFOLD DOOR TRACK SET	2
EXPOTRANS	EXPOTRANS	QUOTE #3432	18' X 18' CUSTOM LIGHTBOX AS PER QUOTE	3
EXPOTRANS	EXPOTRANS	QUOTE #3432	18' X 18' CUSTOM LIGHTBOX AS PER QUOTE	3
EXPOTRANS	EXPOTRANS	QUOTE #3432	24' X 24' CUSTOM LIGHTBOX AS PER QUOTE	10
EXPOTRANS	EXPOTRANS	QUOTE #3432	24' X 24' CUSTOM D.S. LIGHTBOX AS PER QUOTE	6
EXPOTRANS	EXPOTRANS	QUOTE #3432	43' X 43' CUSTOM LIGHTBOX AS PER QUOTE	1